


SCHEDULE

- N1 - (1) SIGN TYPE DBCL10-REMOTE RW: CHANNEL LETTERS WITH REMOTE RACEWAY
- N2 - (1) SIGN TYPE DBCL10-REMOTE RW: CHANNEL LETTERS WITH REMOTE RACEWAY
- N3 - (1) SIGN TYPE: DBW13: SELF CONTAINED CHANNEL LOGO
- N4 - (1) SIGN TYPE: DBW13: SELF CONTAINED CHANNEL LOGO
- N5 - N/A
- N6 - (4) SIGN TYPE: S/F FREE STANDING MENU BOARD
- N7 - (1) SIGN TYPE: SIGN TYPE CLB: S/F POST MOUNTED DOUBLE ARM CLRNC BAR
- N8 - (1) SIGN TYPE: NON-ILLUMINATED D/F DIRECTIONAL (DRIVE THRU/DRIVE THRU)
- N9 - (1) SIGN TYPE: NON-ILLUMINATED D/F DIRECTIONAL (EXIT ONLY/ THANK YOU)
- N10 - (4) SIGN TYPE: S/F WALL MOUNTED MENU BOARD

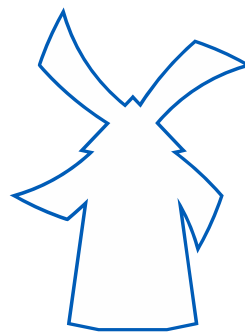

Dutch Bros Coffee

Hillcrest Ave
Antioch, Ca.


SIGN CODE

LEGEND

- N1 NEW PROPOSED
- R1 EXISTING SIGN TO BE REPLACED
- X1 EXISTING SIGN TO BE REMOVED
- S1 EXISTING SIGN TO REMAIN


APPROVAL

X	Title	Date

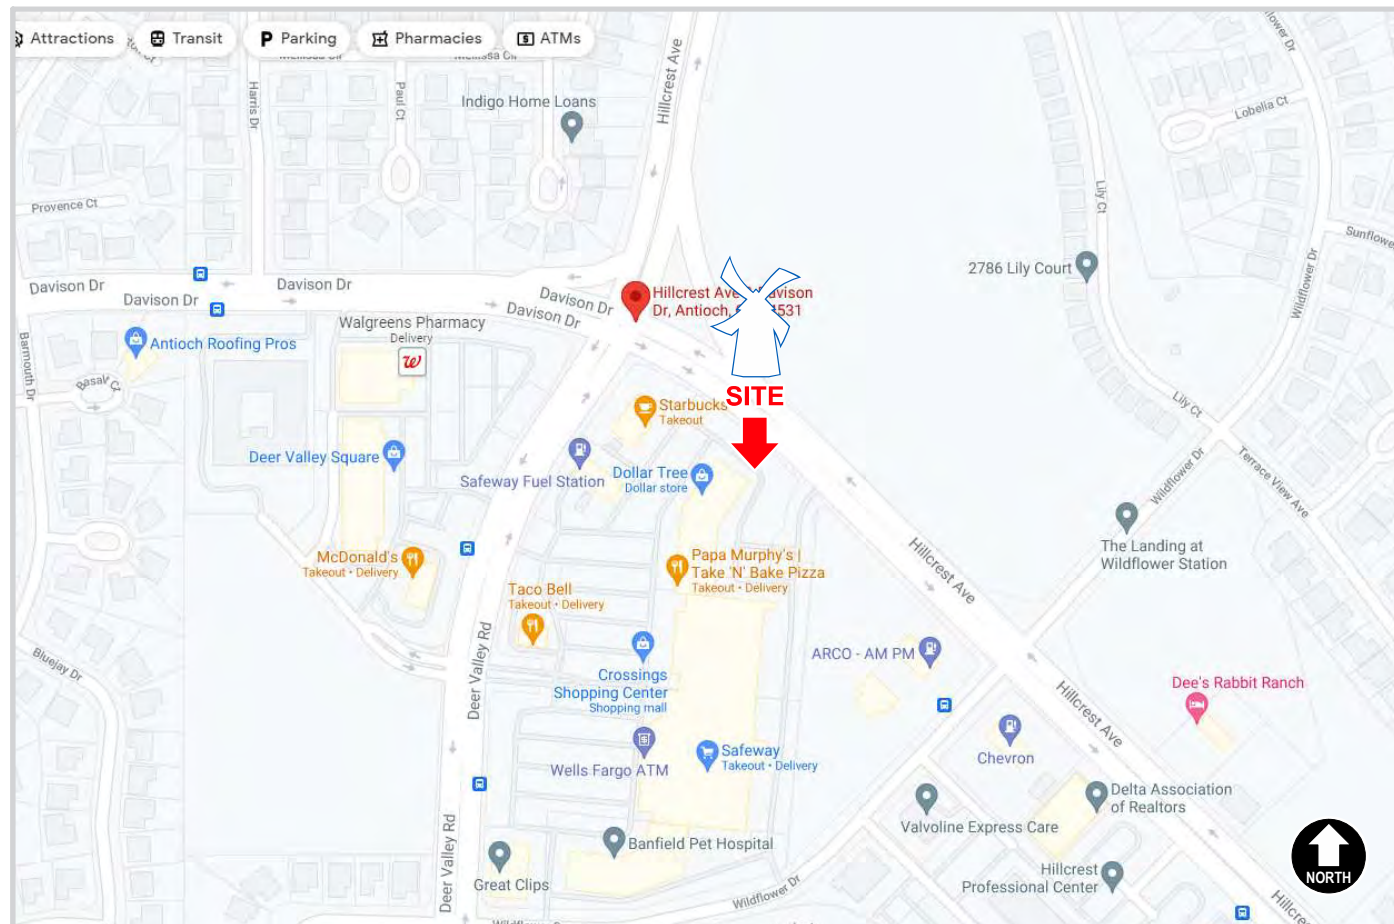

VICINITY MAP

 NOT TO SCALE



AERIAL PHOTO / SITE PLAN

NOT TO SCALE




LOREN

LOREN INDUSTRIES

12226 Coast Drive
Whittier, CA 90601
Tel: (562) 946-7545
Fax: (562) 949-5707
St. Lic.: 455415

Los Angeles, CA

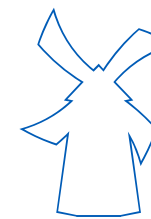

DRAWING/REVISION NO.:

08-21-0001R3

PAGE NO.:

1 OF 15

CLIENT:

DUTCH BROS

ADDRESS

Hillcrest Ave
Antioch, Ca.

Approval Signature

DATE:

08/04/2021

PROJECT MANAGER

Carla T.

DESIGNER:

Jose Soria

REVISION DATE:

08/27/2021

REVISION BY:

Adrian C.

ALL IDEAS, PLANS, AND ELECTRONIC ART INDICATED ON THIS DRAWING ARE COPYRIGHTED AND OWNED BY LOREN ELECTRIC SIGN CORPORATION AND SHALL NOT BE REPRODUCED, USED BY OR DISCLOSED TO ANY PERSONS, FIRM OR CORPORATION FOR ANY PURPOSE WHATSOEVER WITHOUT PERMISSION OF LOREN ELECTRIC SIGN CORPORATION.



LOREN

LOREN INDUSTRIES

12226 Coast Drive
Whittier, CA 90601

Tel: (562) 946-7545

Fax: (562) 949-5707

St. Lic.: 455415

Los Angeles, CA



DRAWING/REVISION NO.:

08-21-0001R3

PAGE NO.:

2 OF 15

CLIENT:

DUTCH BROS

ADDRESS

Hillcrest Ave
Antioch, Ca.

Approval Signature

DATE:

08/04/2021

PROJECT MANAGER

Carla T.

DESIGNER:


Jose Soria

REVISION DATE:

08/27/2021

REVISION BY:

Adrian C.

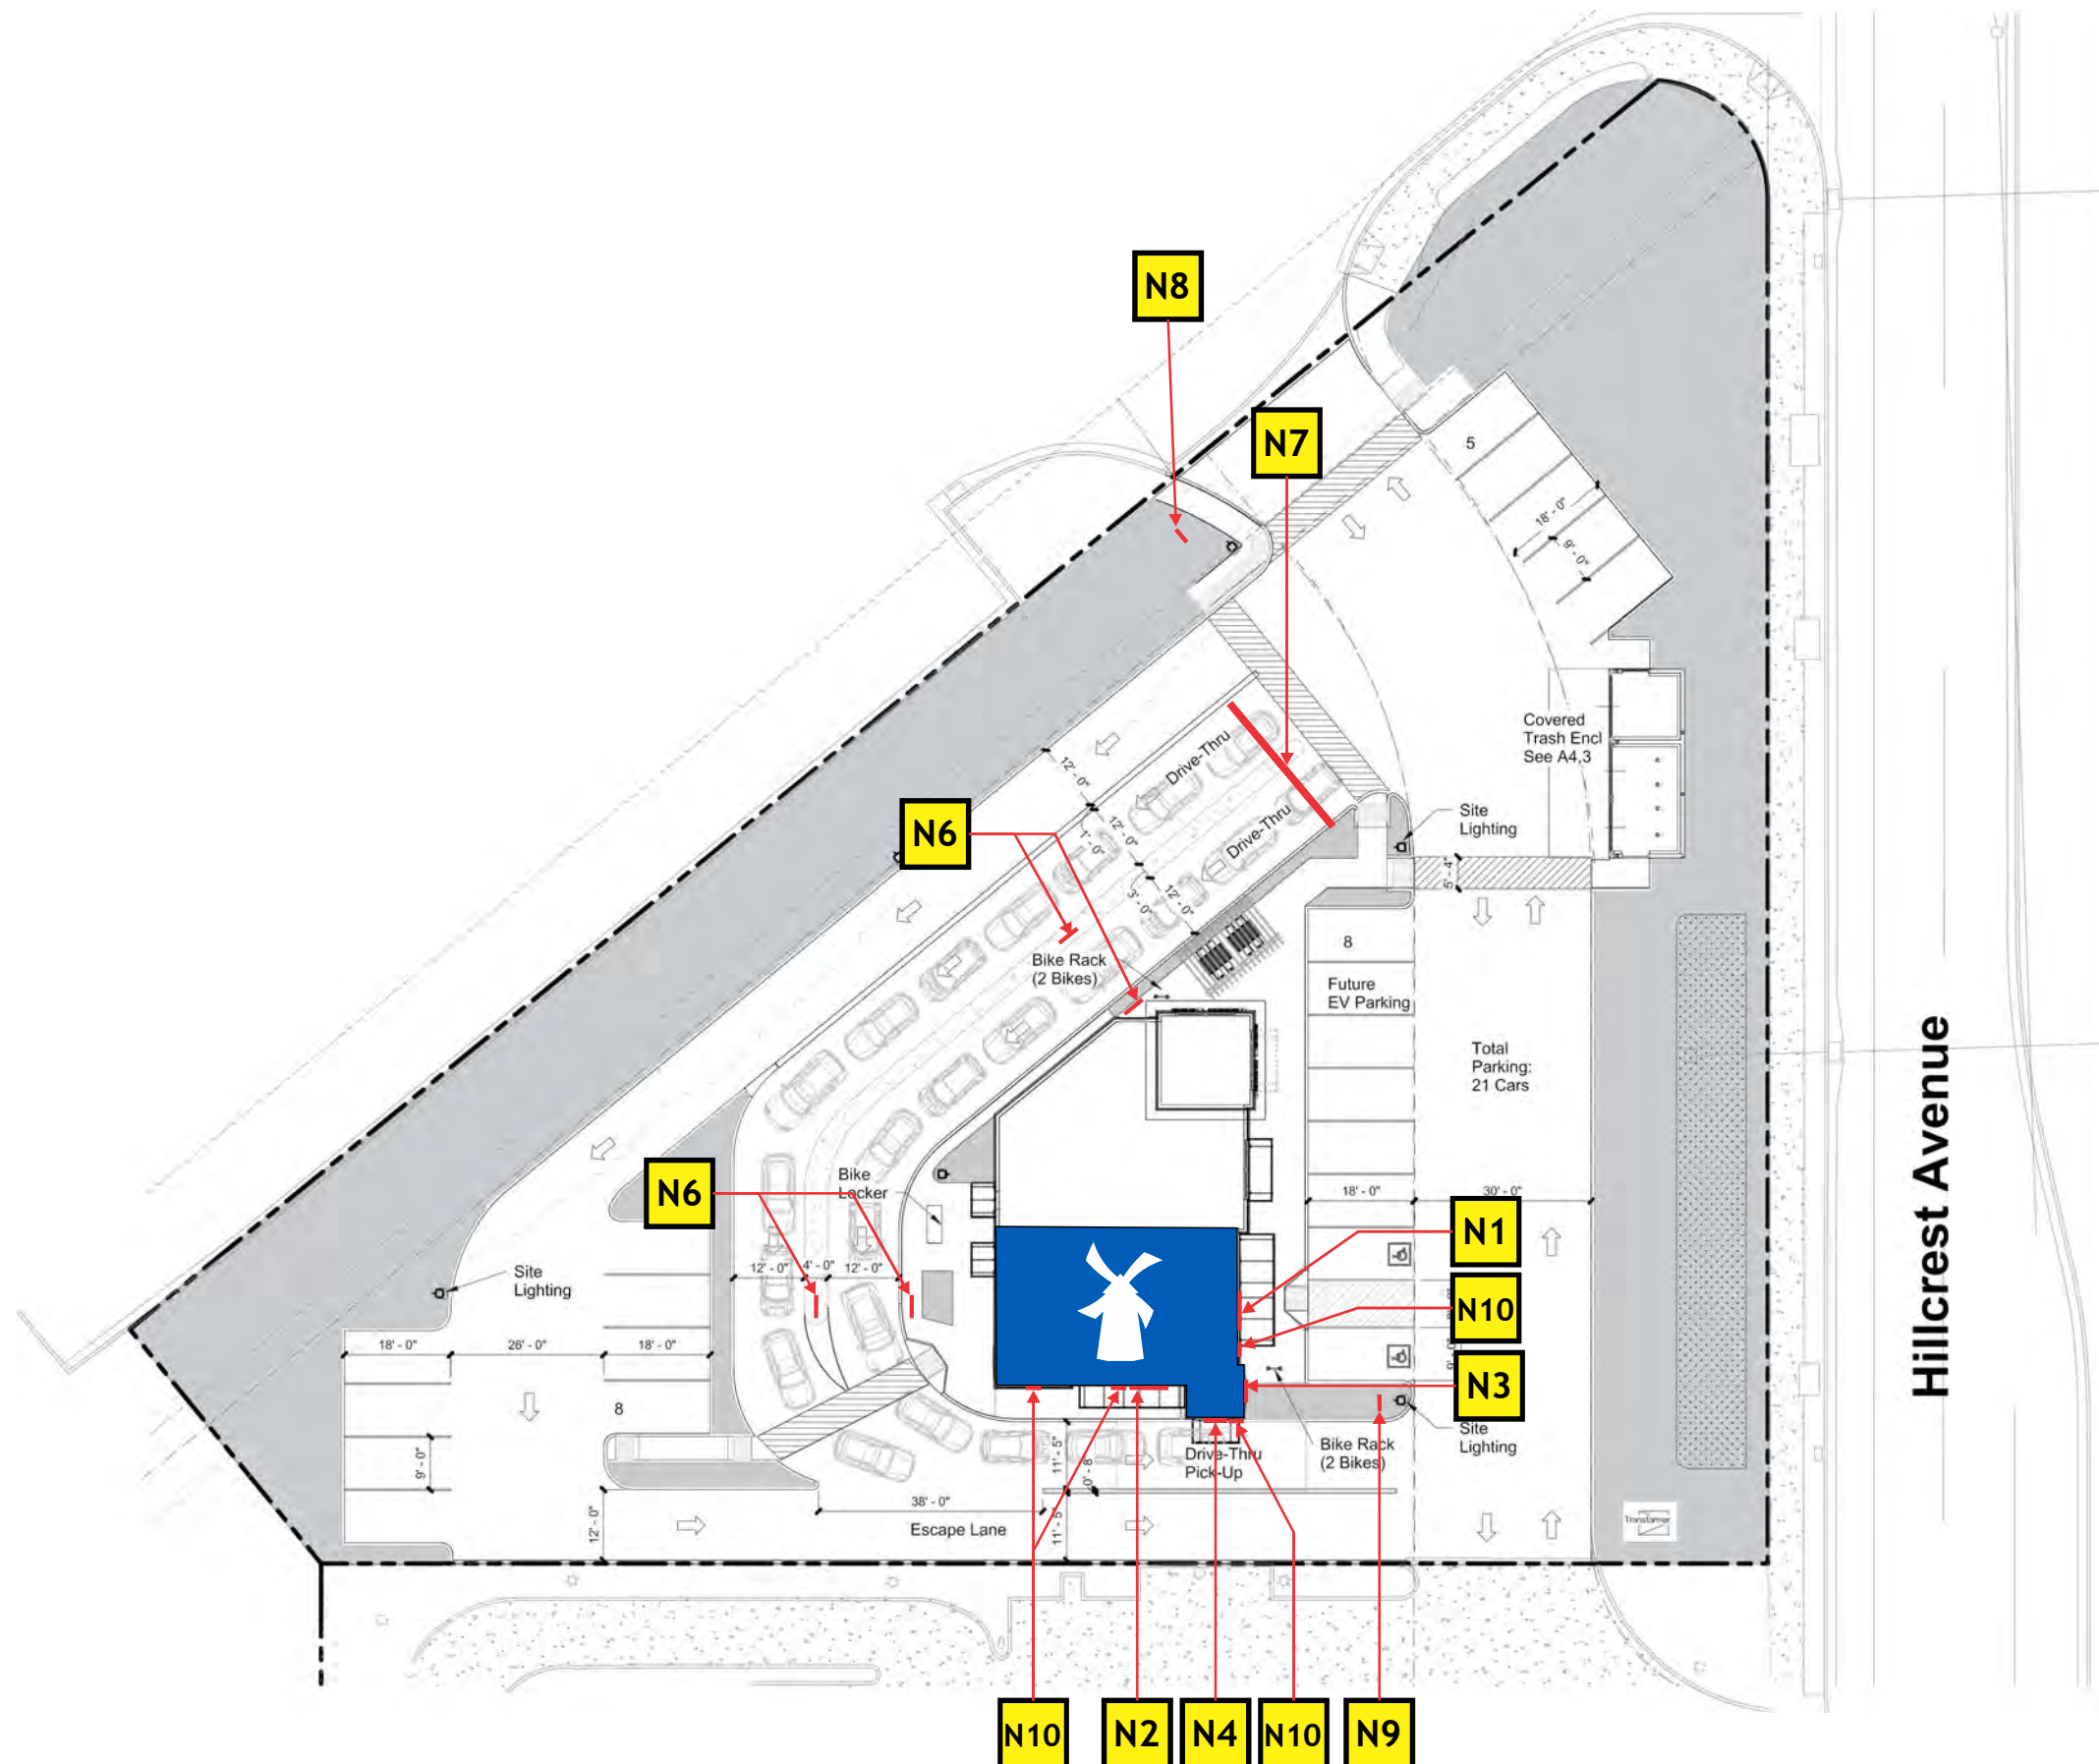


Hillcrest Avenue




SITE PLAN

Scale: 1/32"=1'-0"

 ALL IDEAS, PLANS, AND ELECTRONIC ART INDICATED ON THIS DRAWING ARE COPYRIGHTED AND OWNED BY LOREN ELECTRIC SIGN CORPORATION AND SHALL NOT BE REPRODUCED, USED BY OR DISCLOSED TO ANY PERSONS, FIRM OR CORPORATION FOR ANY PURPOSE WHATSOEVER WITHOUT PERMISSION OF LOREN ELECTRIC SIGN CORPORATION.

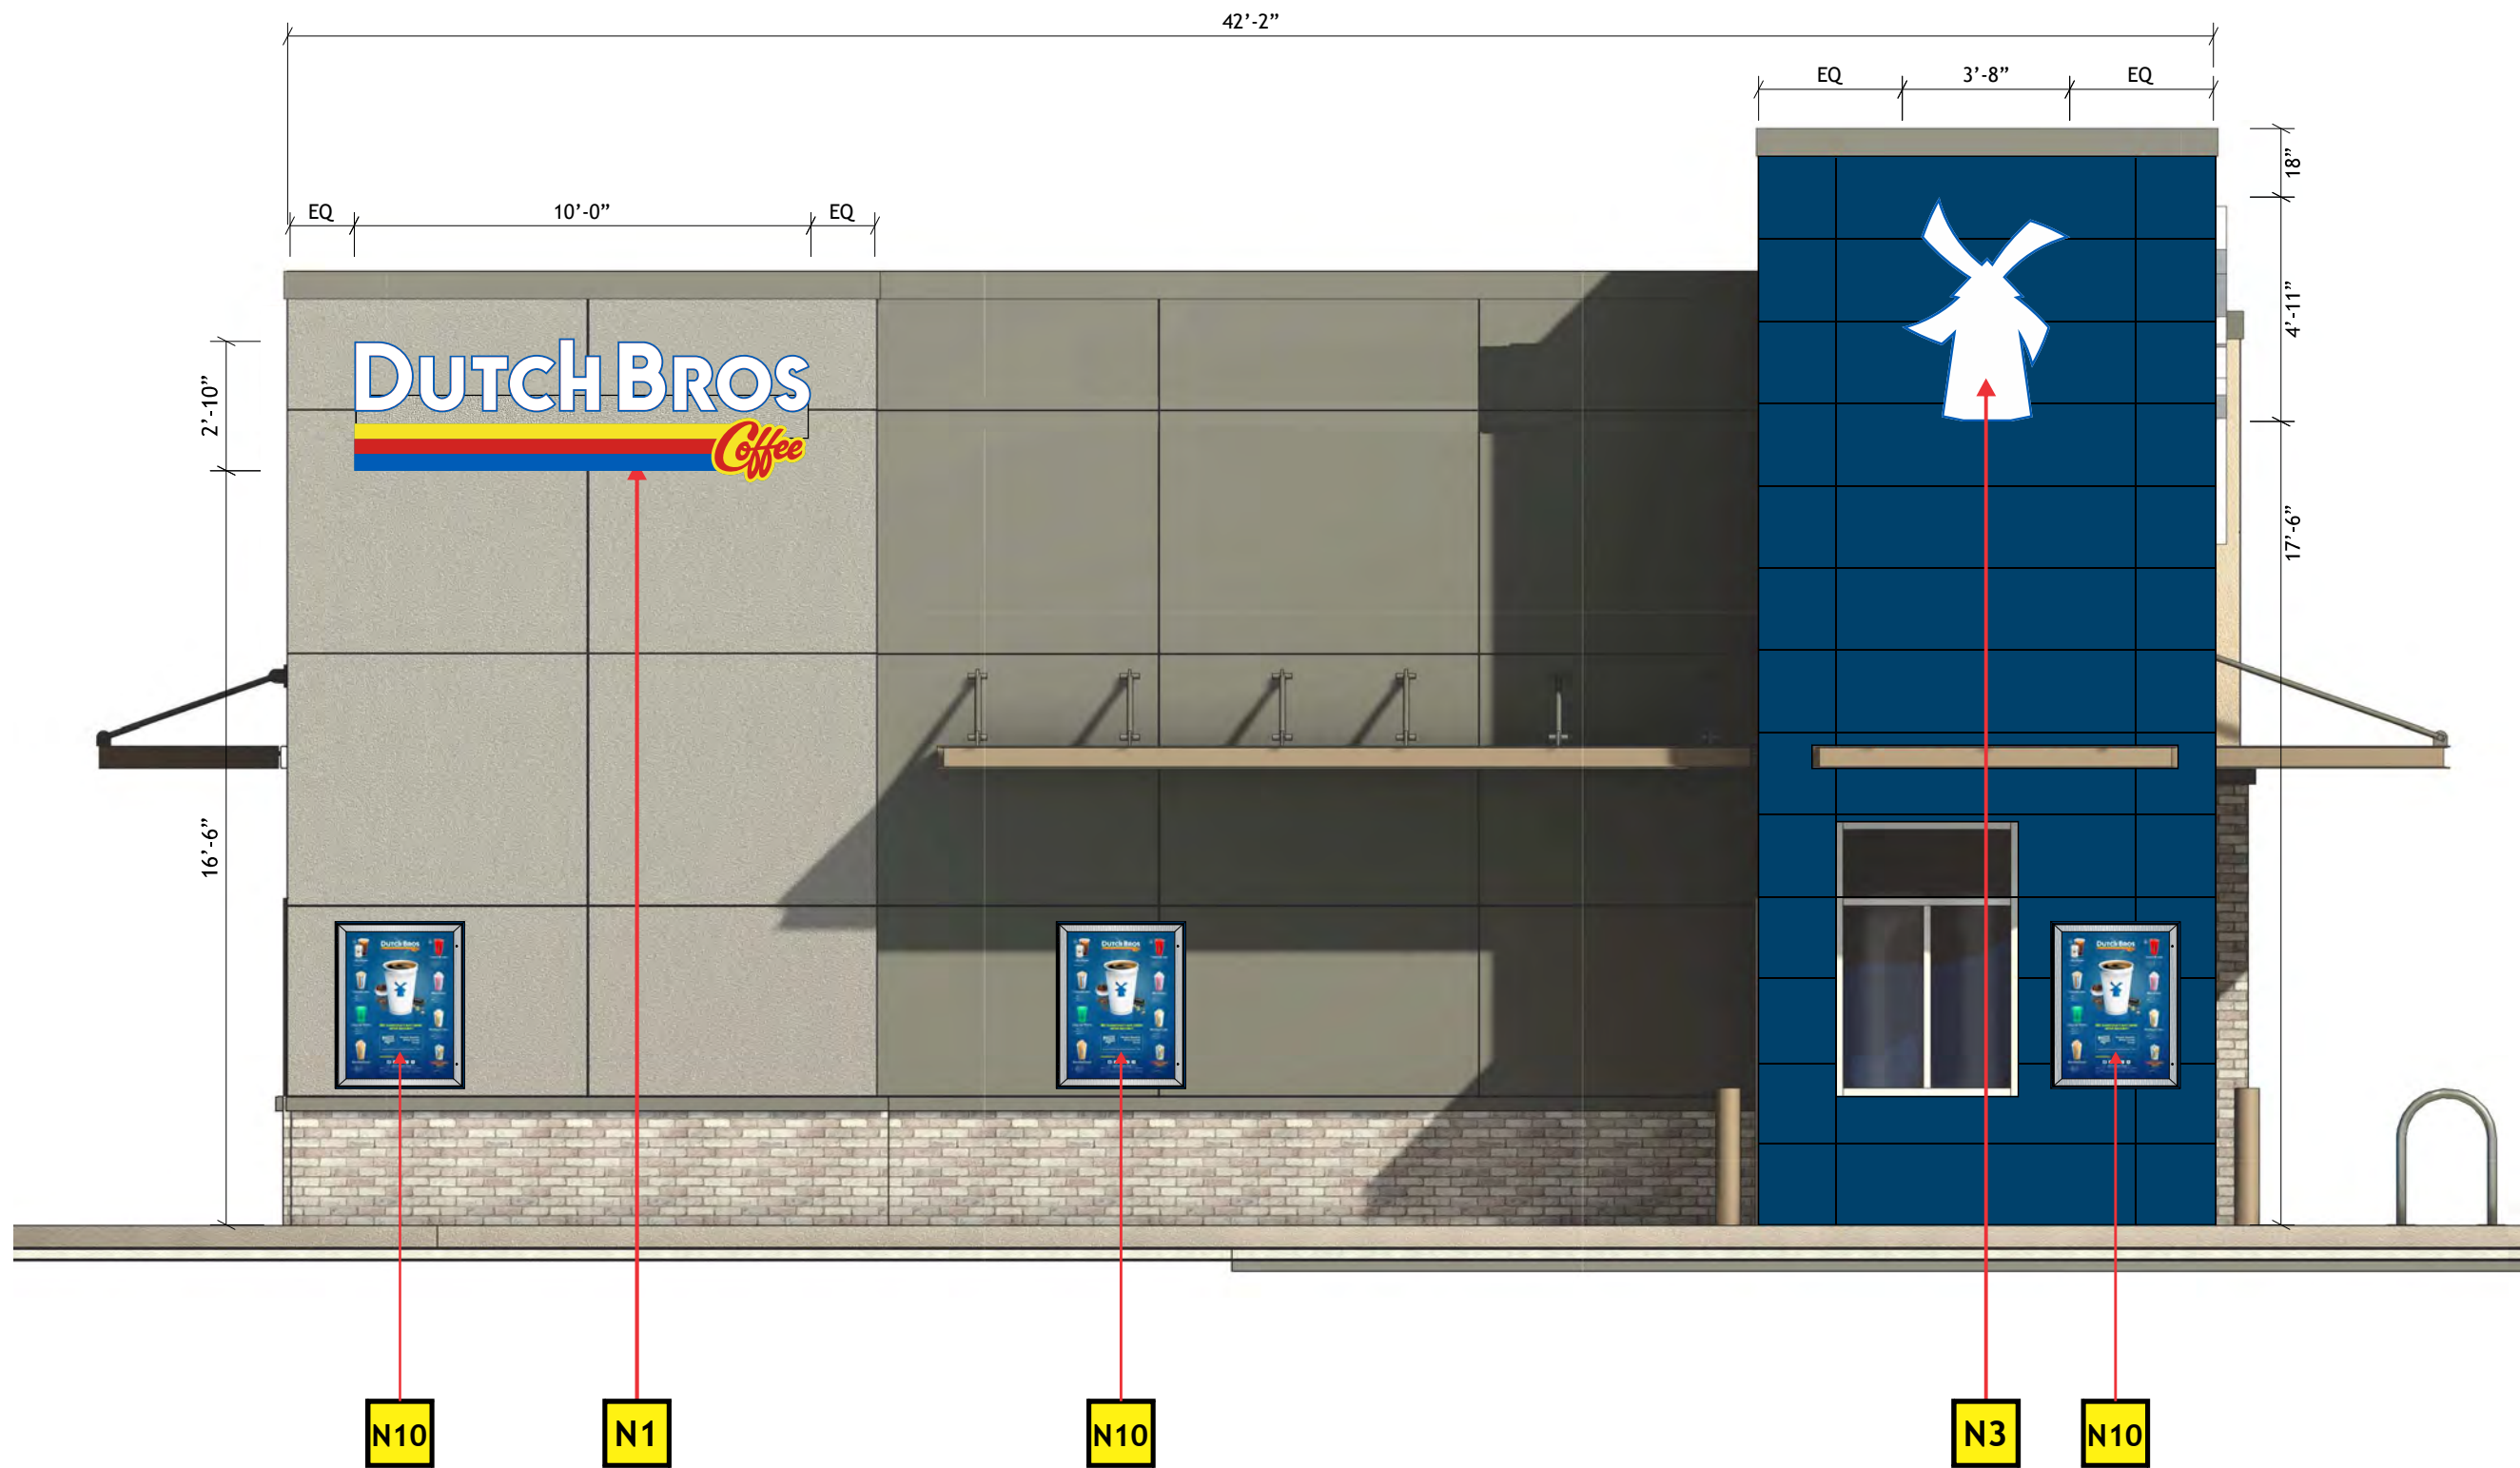

 SOUTH ELEVATION

Scale: 1/4"=1'-0"




LOREN

LOREN INDUSTRIES

12226 Coast Drive
Whittier, CA 90601
Tel: (562) 946-7545
Fax: (562) 949-5707
St. Lic.: 455415

Los Angeles, CA

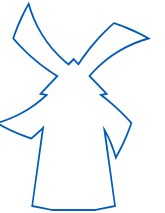

DRAWING/REVISION NO.:

08-21-0001R3

PAGE NO.:

3 OF 15

CLIENT:

DUTCH BROS

ADDRESS

Hillcrest Ave
Antioch, Ca.

Approval Signature

DATE:

08/04/2021

PROJECT MANAGER

Carla T.

DESIGNER:

Jose Soria

REVISION DATE:

08/27/2021

REVISION BY:

Adrian C.

ALL IDEAS, PLANS, AND ELECTRONIC ART INDICATED ON THIS DRAWING ARE COPYRIGHTED AND OWNED BY LOREN ELECTRIC SIGN CORPORATION AND SHALL NOT BE REPRODUCED, USED BY OR DISCLOSED TO ANY PERSONS, FIRM OR CORPORATION FOR ANY PURPOSE WHATSOEVER WITHOUT PERMISSION OF LOREN ELECTRIC SIGN CORPORATION.



LOREN

LOREN INDUSTRIES

12226 Coast Drive
Whittier, CA 90601

Tel: (562) 946-7545

Fax: (562) 949-5707

St. Lic.: 455415

Los Angeles, CA



DRAWING/REVISION NO.:

08-21-0001R3

PAGE NO.:

4 OF 15

CLIENT:

DUTCH BROS

ADDRESS

Hillcrest Ave
Antioch, Ca.

Approval Signature

DATE:

08/04/2021

PROJECT MANAGER

Carla T.

DESIGNER:

Jose Soria


REVISION DATE:

08/27/2021

REVISION BY:

Adrian C.

ALL IDEAS, PLANS, AND ELECTRONIC ART INDICATED ON THIS DRAWING ARE COPYRIGHTED AND OWNED BY LOREN ELECTRIC SIGN CORPORATION AND SHALL NOT BE REPRODUCED, USED BY OR DISCLOSED TO ANY PERSONS, FIRM OR CORPORATION FOR ANY PURPOSE WHATSOEVER WITHOUT PERMISSION OF LOREN ELECTRIC SIGN CORPORATION.

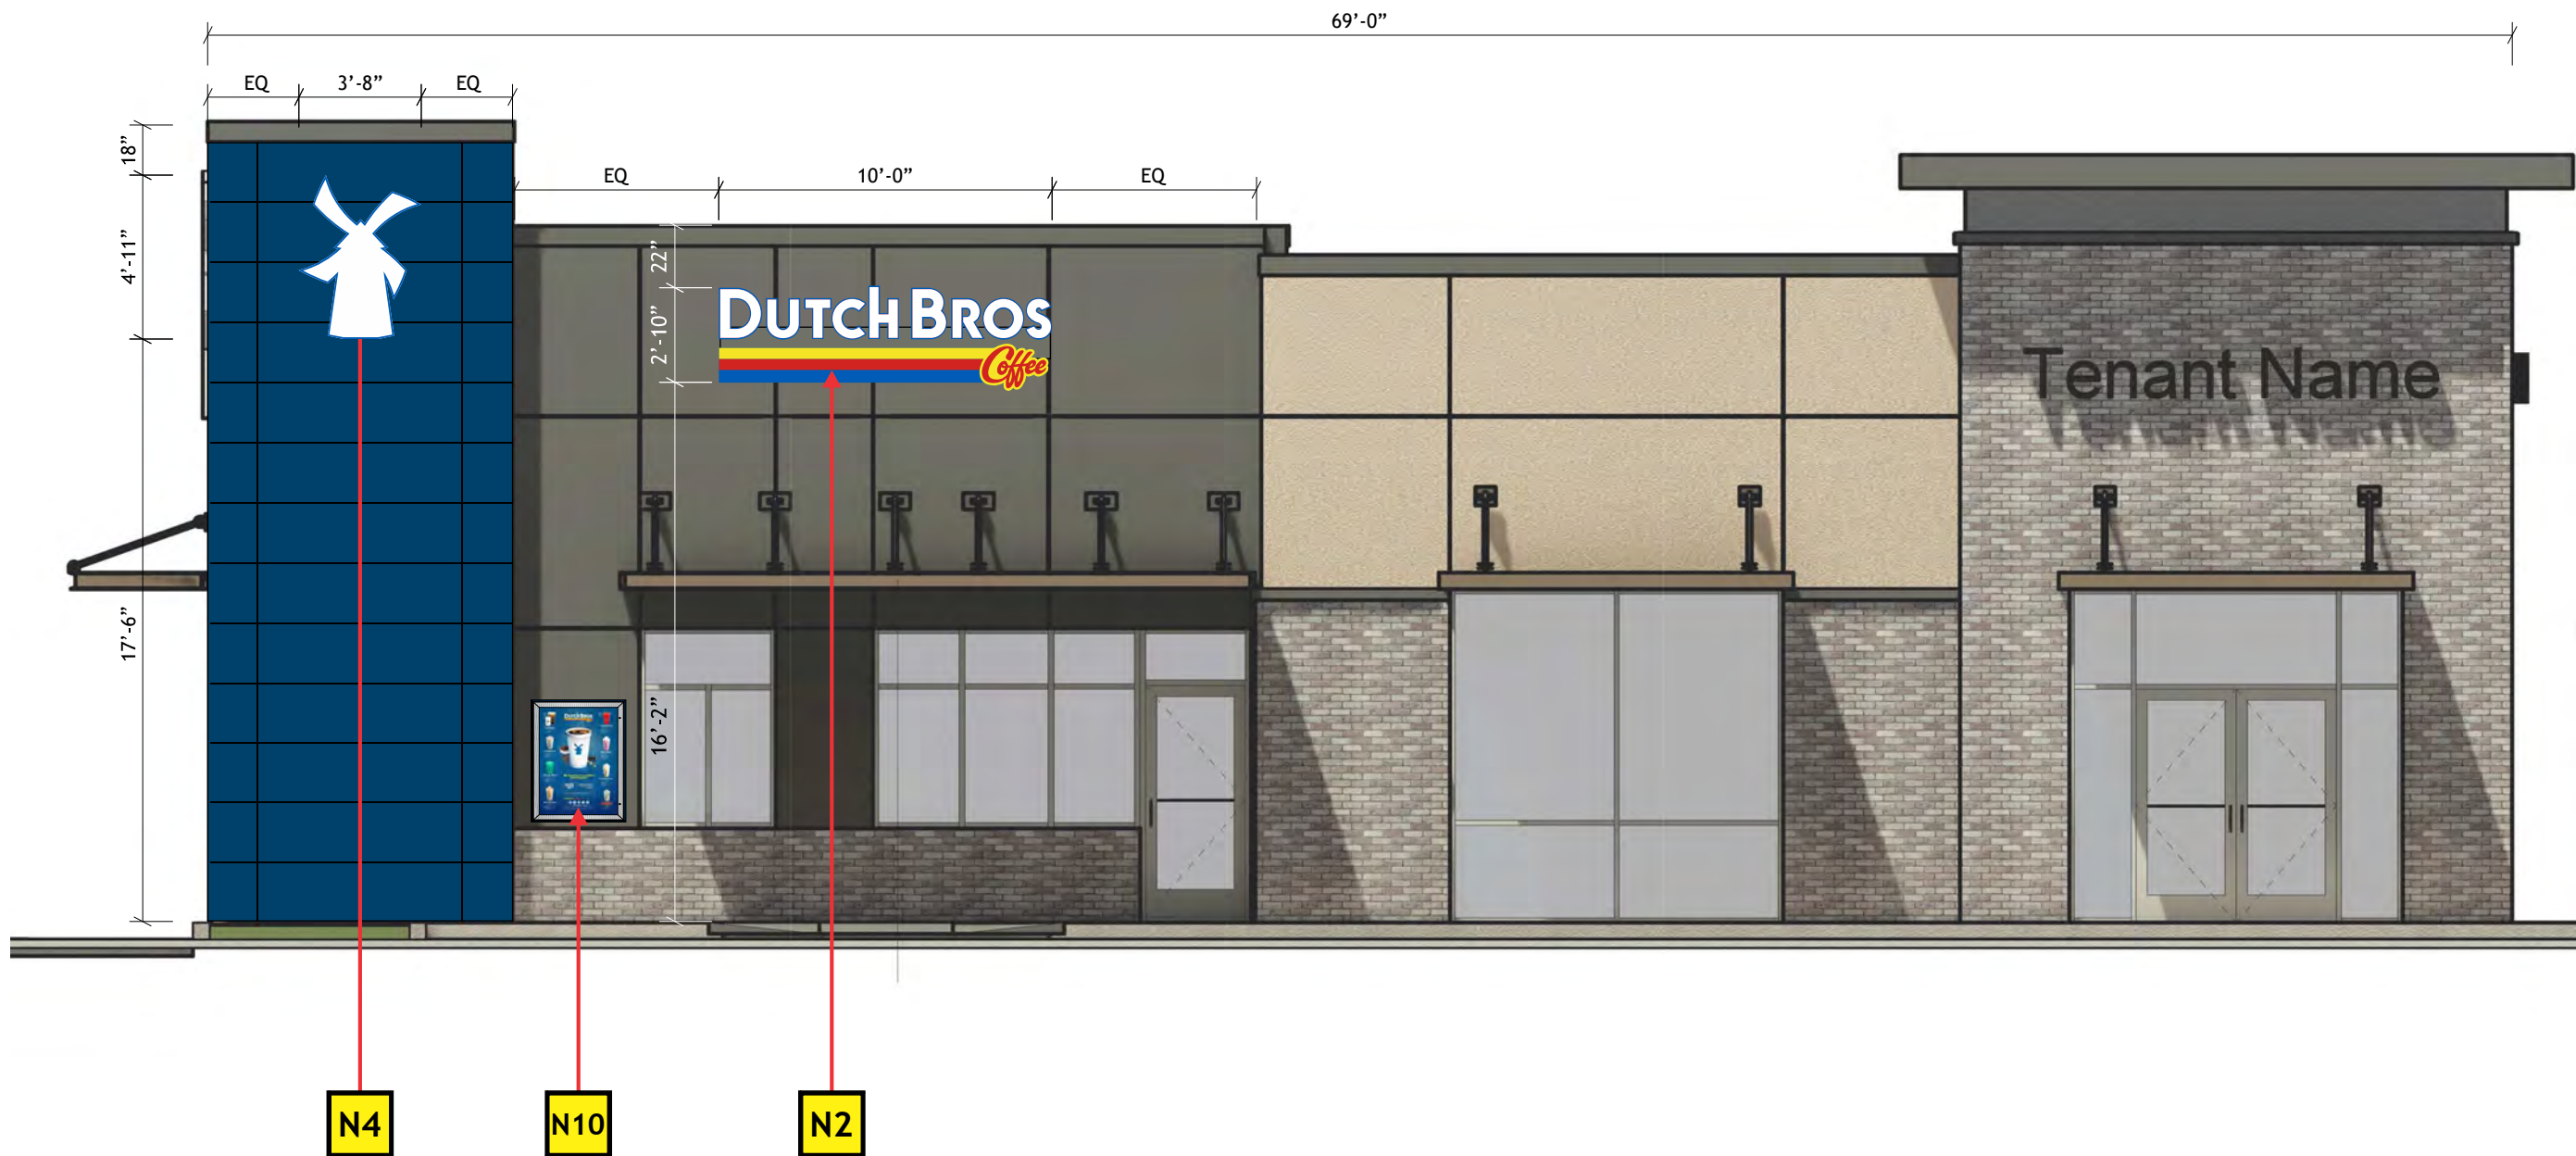

EAST ELEVATION

Scale: 3/16"=1'-0"



LOREN

LOREN INDUSTRIES

12226 Coast Drive
Whittier, CA 90601

Tel: (562) 946-7545

Fax: (562) 949-5707

St. Lic.: 455415

Los Angeles, CA



DRAWING/REVISION NO.:

08-21-0001R3

PAGE NO.:

5 OF 15

CLIENT:

DUTCH BROS

ADDRESS

Hillcrest Ave
Antioch, Ca.

Approval Signature

DATE:

08/04/2021

PROJECT MANAGER

Carla T.

DESIGNER:

Jose Soria

REVISION DATE:

08/27/2021

REVISION BY:

Adrian C.

ALL IDEAS, PLANS, AND ELECTRONIC ART INDICATED ON THIS DRAWING ARE COPYRIGHTED AND OWNED BY LOREN ELECTRIC SIGN CORPORATION AND SHALL NOT BE REPRODUCED, USED BY OR DISCLOSED TO ANY PERSONS, FIRM OR CORPORATION FOR ANY PURPOSE WHATSOEVER WITHOUT PERMISSION OF LOREN ELECTRIC SIGN CORPORATION.

62'-8"



 WEST ELEVATION

Scale: 3/16"=1'-0"




LOREN

LOREN INDUSTRIES

12226 Coast Drive
Whittier, CA 90601
Tel: (562) 946-7545
Fax: (562) 949-5707
St. Lic.: 455415

Los Angeles, CA

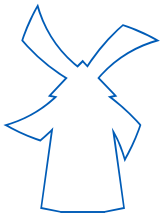

DRAWING/REVISION NO.:

08-21-0001R3

PAGE NO.:

6 OF 15

CLIENT:

DUTCH BROS

ADDRESS

Hillcrest Ave
Antioch, Ca.

Approval Signature

DATE:

08/04/2021

PROJECT MANAGER

Carla T.

DESIGNER:

Jose Soria



REVISION DATE:

08/27/2021

REVISION BY:

Adrian C.

ALL IDEAS, PLANS, AND ELECTRONIC ART INDICATED ON THIS DRAWING ARE COPYRIGHTED AND OWNED BY LOREN ELECTRIC SIGN CORPORATION AND SHALL NOT BE REPRODUCED, USED BY OR DISCLOSED TO ANY PERSONS, FIRM OR CORPORATION FOR ANY PURPOSE WHATSOEVER WITHOUT PERMISSION OF LOREN ELECTRIC SIGN CORPORATION.

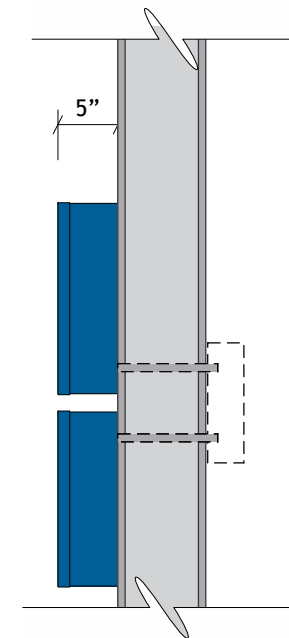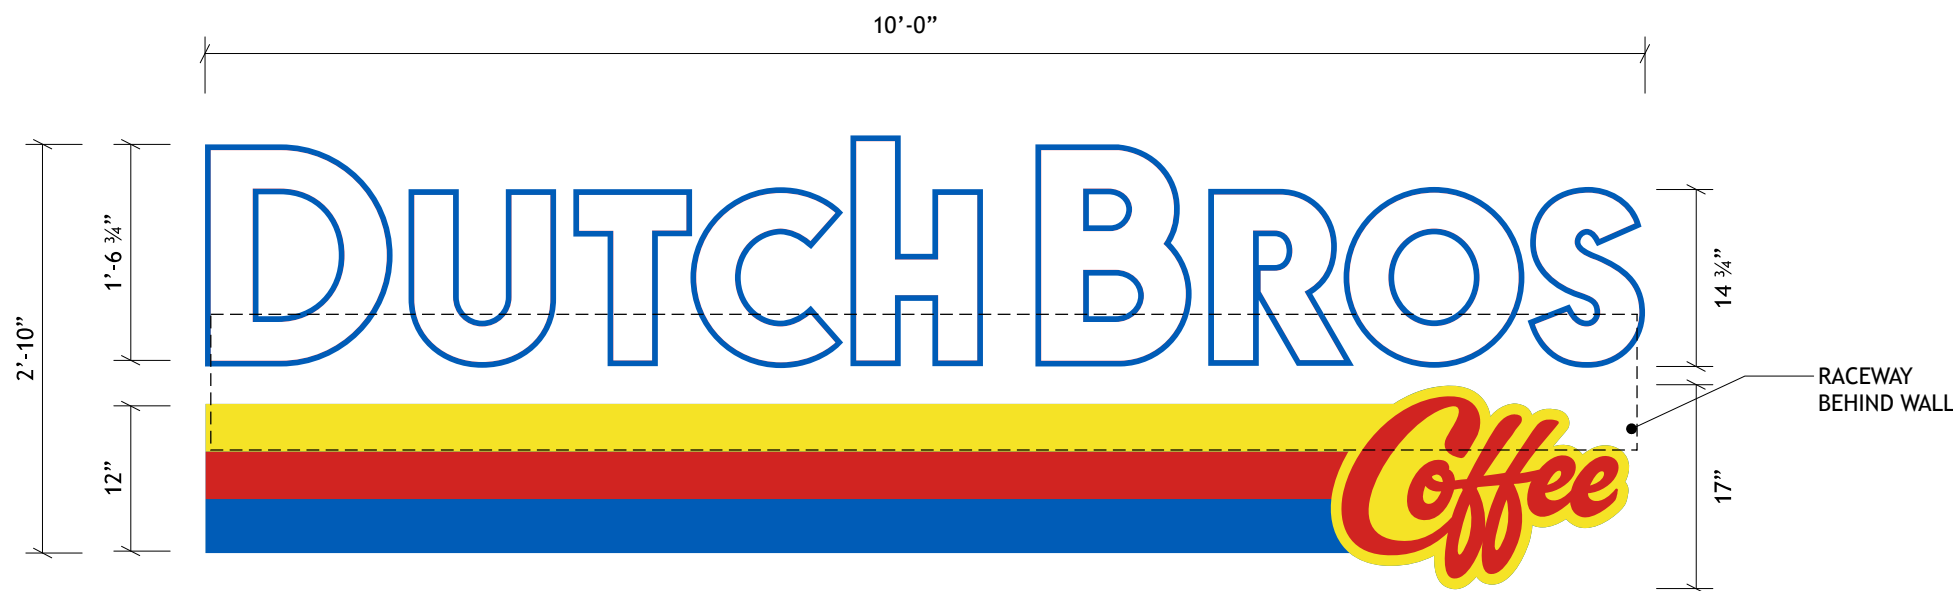

SIDE VIEW

N1 N2

SIGN TYPE DBCL10-REMOTE RW: CHANNEL LETTERS WITH REMOTE RACEWAY

TOTAL SQ. FT.: 28.33






Scale: 3/4" = 1'-0"

SPECIFICATIONS:

LETTERS: **RACEWAY BEHIND WALL**
 FACES:..... 1/8" WHITE ACRYLIC W/1ST SURFACE VINYL
 OUTLINE 230-127 INTENSE BLUE
 RETURNS:..... .040" ALUM. PAINTED TO MATCH PMS 7691C
 TRIMCAP:..... 1" PAINTED TO MATCH PMS 7691C
 ILLUMINATION:..... WHITE LED W/REMOTE POWER SUPPLY

COFFEE UNDERSCORE:
 FACES:..... 1/8" WHITE ACRYLIC W/1ST SURFACE VINYL
 230-127 INTENSE BLUE, 230-33 RED AND
 230-15 YELLOW
 RETURNS:..... .040" ALUM. PAINTED TO MATCH PMS 7691C
 TRIMCAP:..... 1" PAINTED TO MATCH PMS 7691C
 ILLUMINATION:..... WHITE LED W/REMOTE POWER SUPPLY

COLOR SPECIFICATIONS:

-  230-015 YELLOW PSV PMS 116C
-  230-33 RED PSV PMS 1797C
-  230-127 INTENSE BLUE PSV PMS 300C
-  PMS 7691C
-  WHITE

GENERAL NOTES:


- 1.) INSTALLATION OF THIS SIGN SHALL CONFORM TO THE REQUIREMENTS OF ARTICLE 600 OF NEC, UL48 AND/OR OTHER APPLICABLE LOCAL CODES.
- 2.) BRANCH CIRCUIT:
 A.) ALL BRANCH CIRCUITS FOR SIGNS MUST BE TOTALLY DEDICATED TO SIGNS (INCLUDING DEDICATED GROUND AND DEDICATED NEUTRAL PER CIRCUIT).
 B.) SIGN CIRCUITS MUST NOT BE SHARED WITH OTHER LOADS SUCH AS LIGHTING, AIR CONDITIONING AND OTHER EQUIPMENT.
 C.) PROPERTY SIZED GROUND WIRE THAT CAN BE TRACKED TO THE BREAKER PANEL MUST BE PROVIDED.
- 3.) U.L. AND DATA LABELS REQUIRED
- 4.) SIGN SATISFIES ALL REQUIREMENTS OF TITLE 24.
- 5.) OUTDOOR SIGNAGE TO EMPLOY EITHER PHOTOCCELL OR OUTDOOR ASTRONOMICAL TIMER.



LOREN
LOREN INDUSTRIES

12226 Coast Drive
Whittier, CA 90601
Tel: (562) 946-7545
Fax: (562) 949-5707
St. Lic.: 455415

Los Angeles, CA

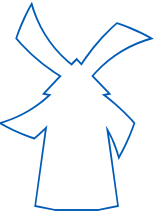

DRAWING/REVISION NO.:

08-21-0001R3

PAGE NO.:

7 OF 15

CLIENT:

DUTCH BROS

ADDRESS

Hillcrest Ave
Antioch, Ca.

Approval Signature

DATE:

08/04/2021

PROJECT MANAGER

Carla T.

DESIGNER:

Jose Soria


REVISION DATE:

08/27/2021

REVISION BY:


Adrian C.

ALL IDEAS, PLANS, AND ELECTRONIC ART INDICATED ON THIS DRAWING ARE COPYRIGHTED AND OWNED BY LOREN ELECTRIC SIGN CORPORATION AND SHALL NOT BE REPRODUCED, USED BY OR DISCLOSED TO ANY PERSONS, FIRM OR CORPORATION FOR ANY PURPOSE WHATSOEVER WITHOUT PERMISSION OF LOREN ELECTRIC SIGN CORPORATION.

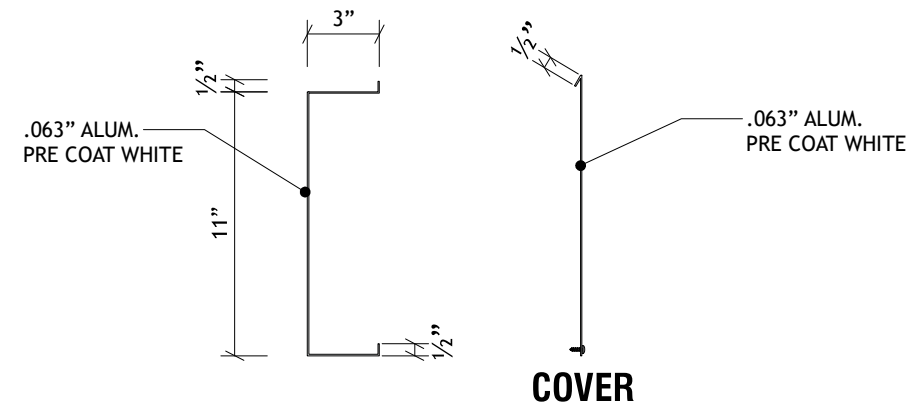


RACEWAY DETAIL

Scale: 1" = 1'-0"

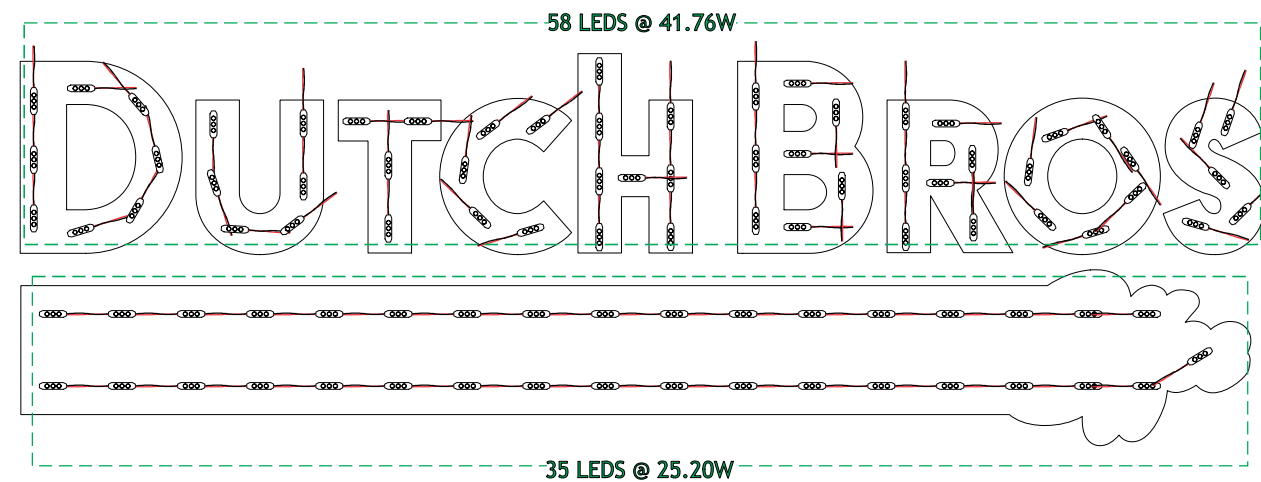

LED LAYOUT

NTS

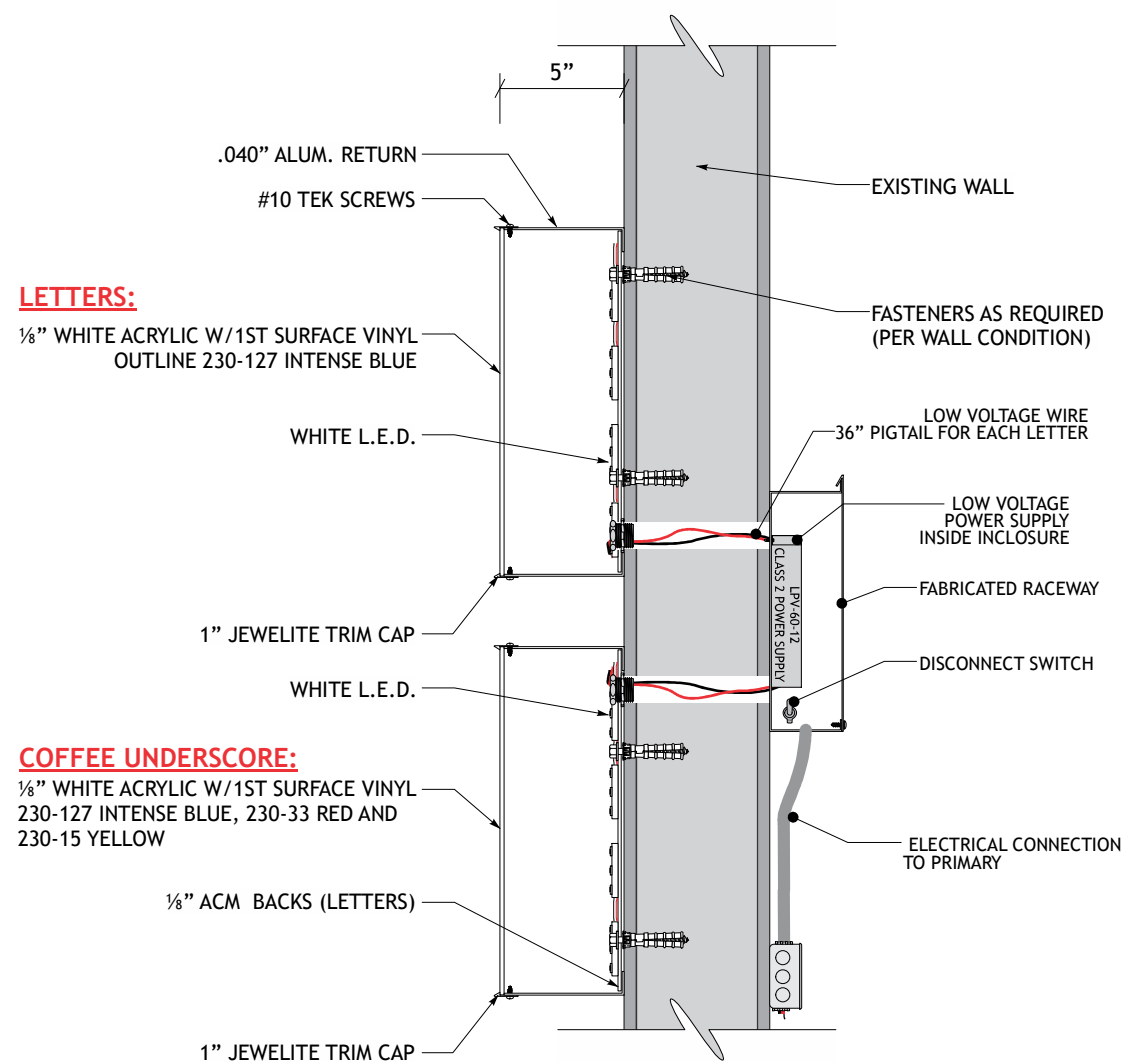

LETTERS:

1/8" WHITE ACRYLIC W/1ST SURFACE VINYL
OUTLINE 230-127 INTENSE BLUE

WHITE L.E.D.

COFFEE UNDERSCORE:

1/8" WHITE ACRYLIC W/1ST SURFACE VINYL
230-127 INTENSE BLUE, 230-33 RED AND
230-15 YELLOW

WHITE L.E.D.

1/8" ACM BACKS (LETTERS)

1" JEWELITE TRIM CAP

NOTES:

ELECTRICAL COMPONENTS TO BE UL LISTED AND INSTALLED IN ACCORDANCE WITH THE NATIONAL ELECTRIC CODE (NEC)

ALL WIRING SHALL BE 12 GA

(1) 20 AMP-120V CIRCUIT TO BE BROUGHT TO JOB SITE BY LICENCED ELECTRICIAN.

ALL SIGNAGE WILL BE UL2161 COMPLIANT AND CARRY UL LABELS.

ELECTRICAL SPECIFICATIONS

LETTERS & COFFEE UNDERSCORE:

(93) WHITE LED MODULES @ 0.72W EA= 66.96W TOTAL
(1) 12V 100W POWER SUPPLIES @ 2.2 AMPS EA.

(1) CUSTOMER PROVIDED 120V/20A/60HZ DEDICATED CIRCUIT REQUIRED

**TOTAL CIRCUIT LOAD:
2.2 AMPS @ 120 VAC**

GENERAL NOTES:


- 1.) INSTALLATION OF THIS SIGN SHALL CONFORM TO THE REQUIREMENTS OF ARTICLE 600 OF NEC, UL48 AND/OR OTHER APPLICABLE LOCAL CODES.
- 2.) BRANCH CIRCUIT:
 - A.) ALL BRANCH CIRCUITS FOR SIGNS MUST BE TOTALLY DEDICATED TO SIGNS (INCLUDING DEDICATED GROUND AND DEDICATED NEUTRAL PER CIRCUIT).
 - B.) SIGN CIRCUITS MUST NOT BE SHARED WITH OTHER LOADS SUCH AS LIGHTING, AIR CONDITIONING AND OTHER EQUIPMENT.
 - C.) PROPERTY SIZED GROUND WIRE THAT CAN BE TRACKED TO THE BREAKER PANEL MUST BE PROVIDED.
- 3.) U.L. AND DATA LABELS REQUIRED
- 4.) SIGN SATISFIES ALL REQUIREMENTS OF TITLE 24.
- 5.) OUTDOOR SIGNAGE TO EMPLOY EITHER PHOTOCCELL OR OUTDOOR ASTRONOMICAL TIMER



ELECTRIC SIGN SECTION

THIS SIGN IS INTENDED TO BE INSTALLED IN ACCORDANCE WITH THE REQUIREMENTS OF ARTICLE 600 OF THE NATIONAL ELECTRICAL CODE AND/OR OTHER APPLICABLE LOCAL CODES.

THIS INCLUDES PROPER GROUNDING AND BONDING OF THE SIGN.

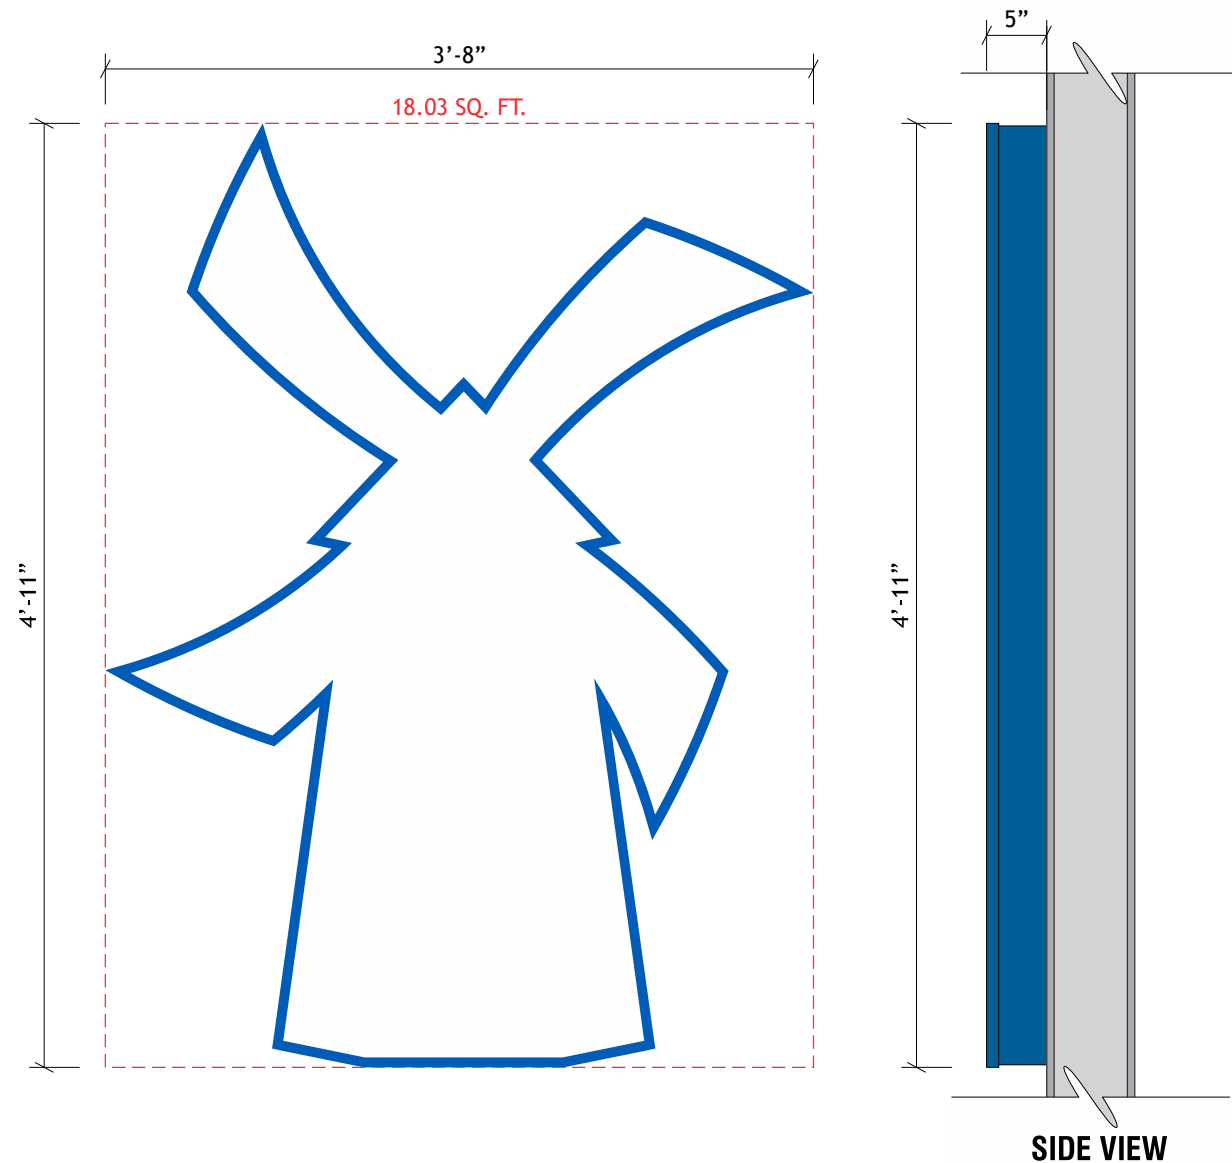

COLOR SPECIFICATIONS:

	230-015 YELLOW PSV PMS 116C
	230-33 RED PSV PMS 1797C
	230-127 INTENSE BLUE PSV PMS 300C
	PMS 7691C
	WHITE

SPECIFICATIONS:

LOGO: SELF CONTAINED

FACES:..... 3/16" WHITE ACRYLIC W/1ST SURFACE VINYL
OUTLINE 230-127 INTENSE BLUE

RETURNS:..... .040" ALUM. PAINTED TO MATCH PMS 7691C

TRIMCAP:..... 1" PAINTED TO MATCH PMS 7691C

ILLUMINATION:..... WHITE LED W/SELF CONTAINED POWER SUPPLY

N3 N4

SIGN TYPE DBW13 : SELF CONTAINED LOGO
TOTAL SQ. FT.: 18.03

Scale: 1" = 1'-0"

GENERAL NOTES:


- 1.) INSTALLATION OF THIS SIGN SHALL CONFORM TO THE REQUIREMENTS OF ARTICLE 600 OF NEC, UL48 AND/OR OTHER APPLICABLE LOCAL CODES.
- 2.) BRANCH CIRCUIT:
 - A.) ALL BRANCH CIRCUITS FOR SIGNS MUST BE TOTALLY DEDICATED TO SIGNS (INCLUDING DEDICATED GROUND AND DEDICATED NEUTRAL PER CIRCUIT).
 - B.) SIGN CIRCUITS MUST NOT BE SHARED WITH OTHER LOADS SUCH AS LIGHTING, AIR CONDITIONING AND OTHER EQUIPMENT.
 - C.) PROPERTY SIZED GROUND WIRE THAT CAN BE TRACKED TO THE BREAKER PANEL MUST BE PROVIDED.
- 3.) U.L. AND DATA LABELS REQUIRED
- 4.) SIGN SATISFIES ALL REQUIREMENTS OF TITLE 24.
- 5.) OUTDOOR SIGNAGE TO EMPLOY EITHER PHOTOCCELL OR OUTDOOR ASTRONOMICAL TIMER.



LOREN INDUSTRIES

12226 Coast Drive
Whittier, CA 90601
Tel: (562) 946-7545
Fax: (562) 949-5707
St. Lic.: 455415

Los Angeles, CA

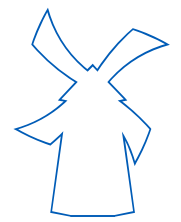

DRAWING/REVISION NO.:

08-21-0001R3

PAGE NO.:

8 OF 15

CLIENT:

DUTCH BROS

ADDRESS

Hillcrest Ave
Antioch, Ca.

Approval Signature

DATE:

08/04/2021

PROJECT MANAGER

Carla T.

DESIGNER:

Jose Soria


REVISION DATE:

08/27/2021


REVISION BY:

Adrian C.

ALL IDEAS, PLANS, AND ELECTRONIC ART INDICATED ON THIS DRAWING ARE COPYRIGHTED AND OWNED BY LOREN ELECTRIC SIGN CORPORATION AND SHALL NOT BE REPRODUCED, USED BY OR DISCLOSED TO ANY PERSONS, FIRM OR CORPORATION FOR ANY PURPOSE WHATSOEVER WITHOUT PERMISSION OF LOREN ELECTRIC SIGN CORPORATION.

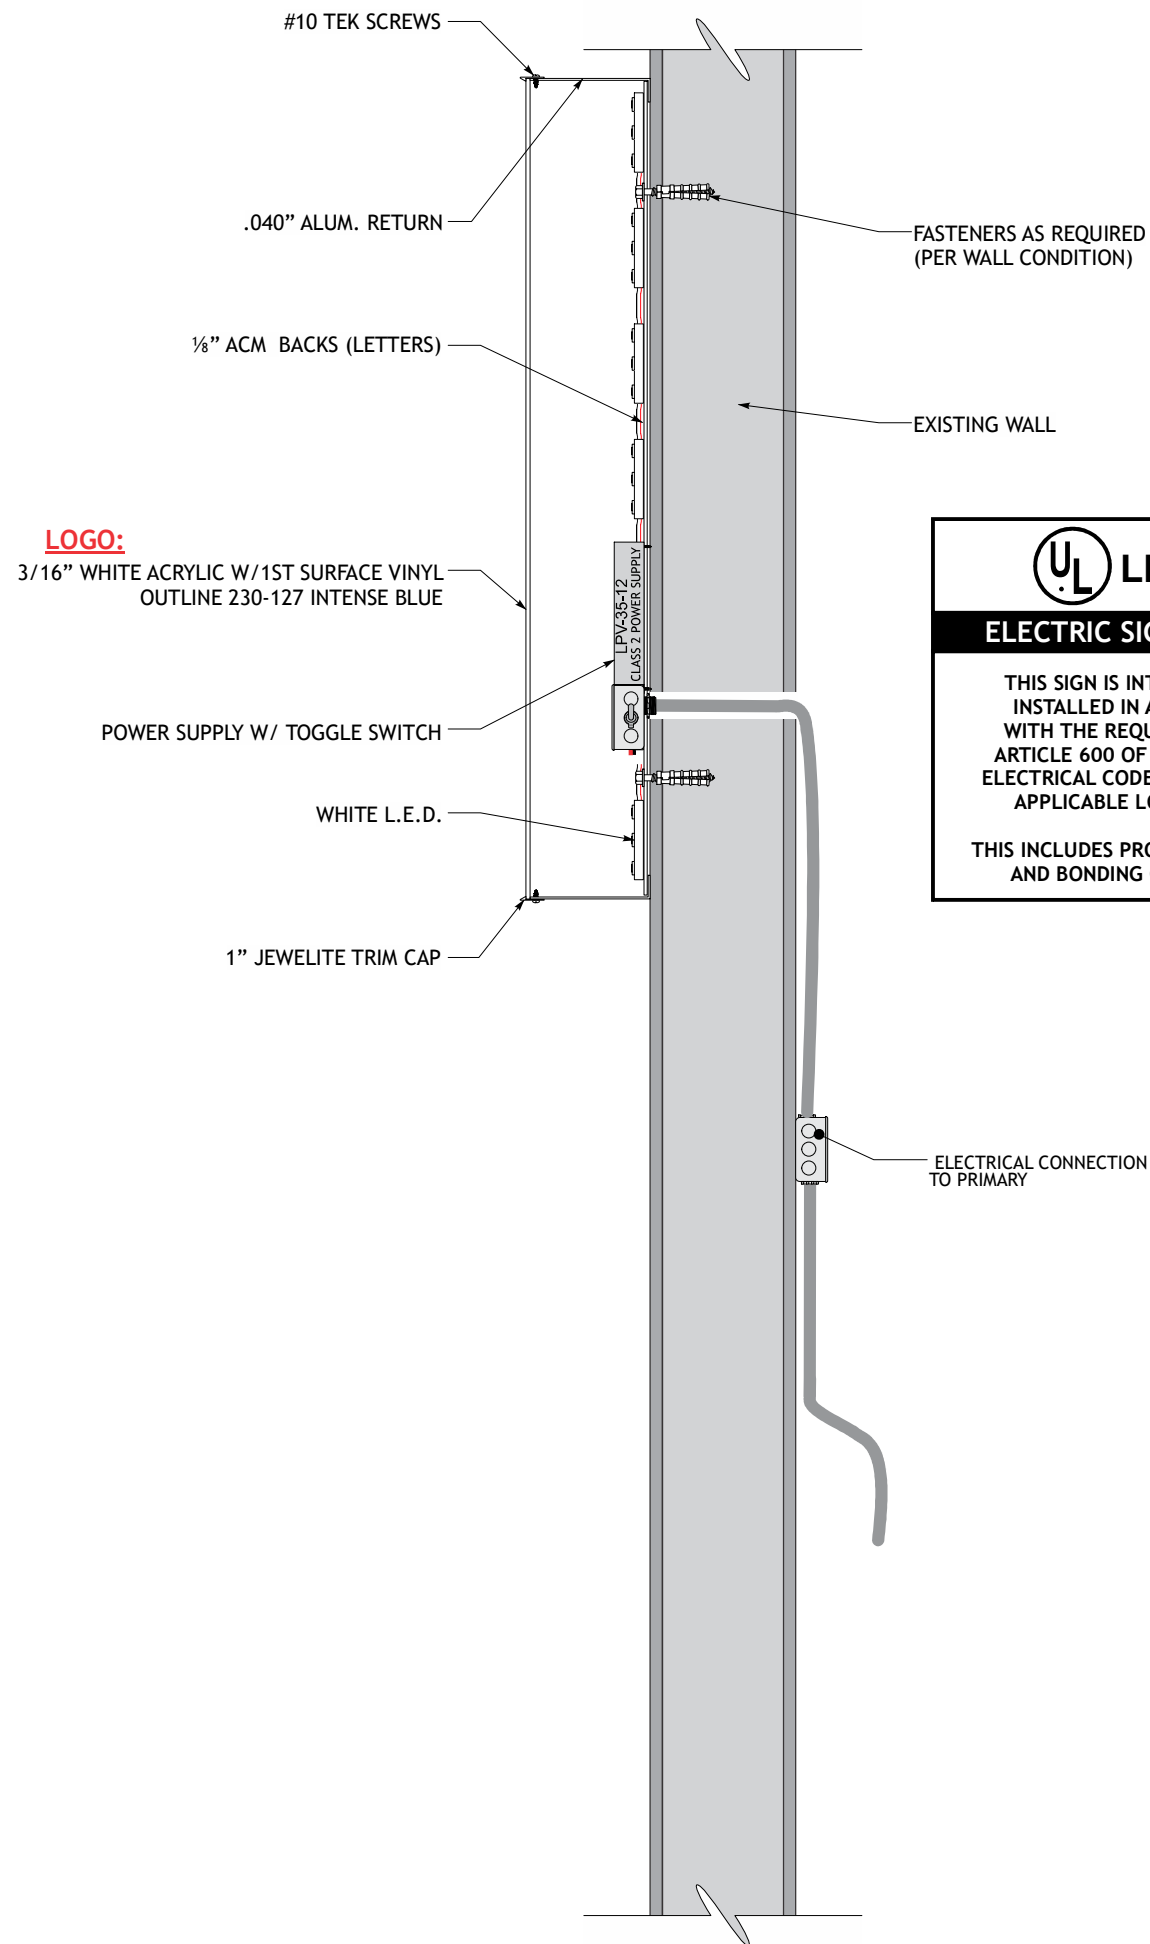

UL LISTED
ELECTRIC SIGN SECTION
 THIS SIGN IS INTENDED TO BE INSTALLED IN ACCORDANCE WITH THE REQUIREMENTS OF ARTICLE 600 OF THE NATIONAL ELECTRICAL CODE AND/OR OTHER APPLICABLE LOCAL CODES.
 THIS INCLUDES PROPER GROUNDING AND BONDING OF THE SIGN.

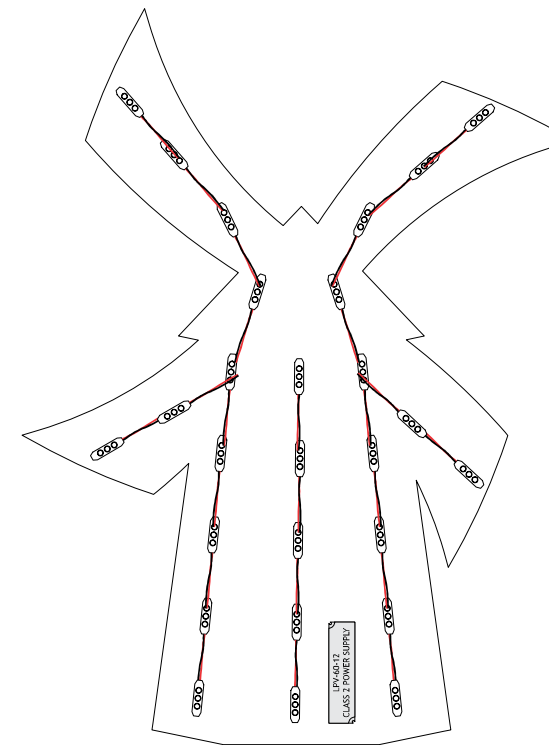

LED LAYOUT

NTS

NOTES:

ELECTRICAL COMPONENTS TO BE UL LISTED AND INSTALLED IN ACCORDANCE WITH THE NATIONAL ELECTRIC CODE (NEC)

ALL WIRING SHALL BE 12 GA

(1) 20 AMP-120V CIRCUIT TO BE BROUGHT TO JOB SITE BY LICENCED ELECTRICIAN.

ALL SIGNAGE WILL BE UL2161 COMPLIANT AND CARRY UL LABELS.

ELECTRICAL SPECIFICATIONS
LOGO:
 (27) WHITE LED MODULES @ 0.72W EA= 19.44W TOTAL
 (1) 12V 35W POWER SUPPLIES @ 1.1 AMPS EA.
 (1) CUSTOMER PROVIDED 120V/20A/60HZ DEDICATED CIRCUIT REQUIRED
TOTAL CIRCUIT LOAD:
1.1 AMPS @ 120 VAC

GENERAL NOTES:


- 1.) INSTALLATION OF THIS SIGN SHALL CONFORM TO THE REQUIREMENTS OF ARTICLE 600 OF NEC, UL48 AND/OR OTHER APPLICABLE LOCAL CODES.
- 2.) BRANCH CIRCUIT:
 - A.) ALL BRANCH CIRCUITS FOR SIGNS MUST BE TOTALLY DEDICATED TO SIGNS (INCLUDING DEDICATED GROUND AND DEDICATED NEUTRAL PER CIRCUIT).
 - B.) SIGN CIRCUITS MUST NOT BE SHARED WITH OTHER LOADS SUCH AS LIGHTING, AIR CONDITIONING AND OTHER EQUIPMENT.
 - C.) PROPERTY SIZED GROUND WIRE THAT CAN BE TRACKED TO THE BREAKER PANEL MUST BE PROVIDED.
- 3.) U.L. AND DATA LABELS REQUIRED
- 4.) SIGN SATISFIES ALL REQUIREMENTS OF TITLE 24.
- 5.) OUTDOOR SIGNAGE TO EMPLOY EITHER PHOTOCCELL OR OUTDOOR ASTRONOMICAL TIMER



LOREN INDUSTRIES

12226 Coast Drive
 Whittier, CA 90601
 Tel: (562) 946-7545
 Fax: (562) 949-5707
 St. Lic.: 455415

Los Angeles, CA

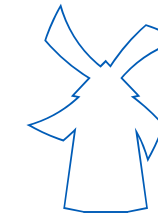

DRAWING/REVISION NO.:

08-21-0001R3

PAGE NO.:

9 OF 15

CLIENT:

DUTCH BROS

ADDRESS

Hillcrest Ave
 Antioch, Ca.

Approval Signature

DATE:

08/04/2021

PROJECT MANAGER

Carla T.

DESIGNER:

Jose Soria

REVISION DATE:


08/27/2021

REVISION BY:

Adrian C.

ALL IDEAS, PLANS, AND ELECTRONIC ART INDICATED ON THIS DRAWING ARE COPYRIGHTED AND OWNED BY LOREN ELECTRIC SIGN CORPORATION AND SHALL NOT BE REPRODUCED, USED BY OR DISCLOSED TO ANY PERSONS, FIRM OR CORPORATION FOR ANY PURPOSE WHATSOEVER WITHOUT PERMISSION OF LOREN ELECTRIC SIGN CORPORATION.

SCOPE OF WORK: PROVIDE (1) S/F ILLUMINATED MENU SIGN - PLATE-MOUNTED

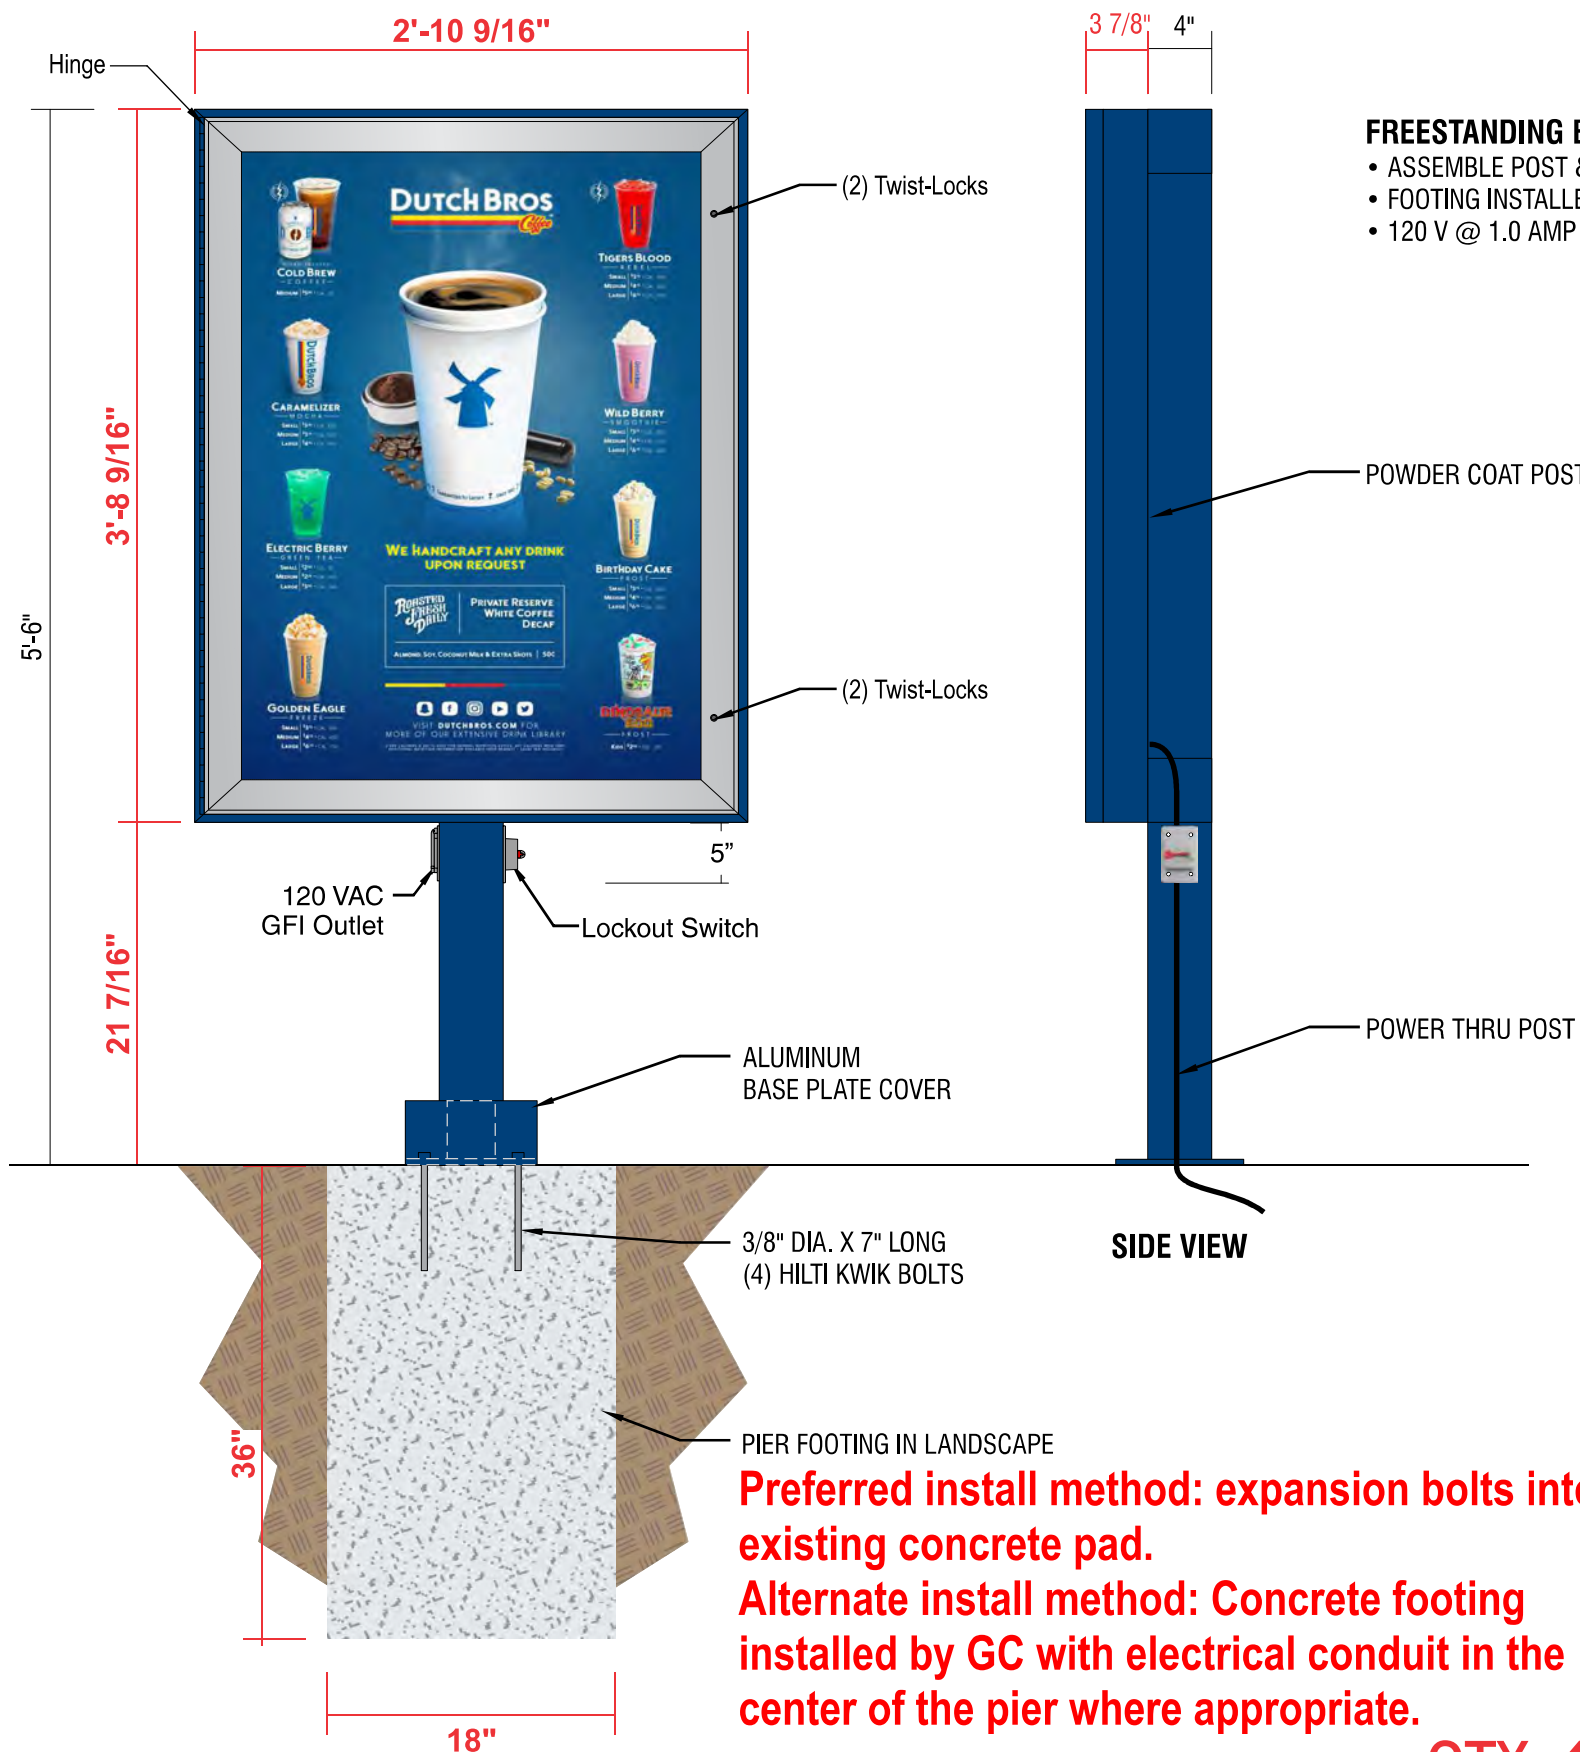


FREESTANDING BACKLIT MENU SIGN

- ASSEMBLE POST & MENU
- FOOTING INSTALLED BY G.C.
- 120 V @ 1.0 AMP

COLOR CODE

- DIGITAL PRINT
- DB CUSTOM DARK BLUE

**INSTALLATION ORIENTATION DETAIL
NOT TO SCALE**

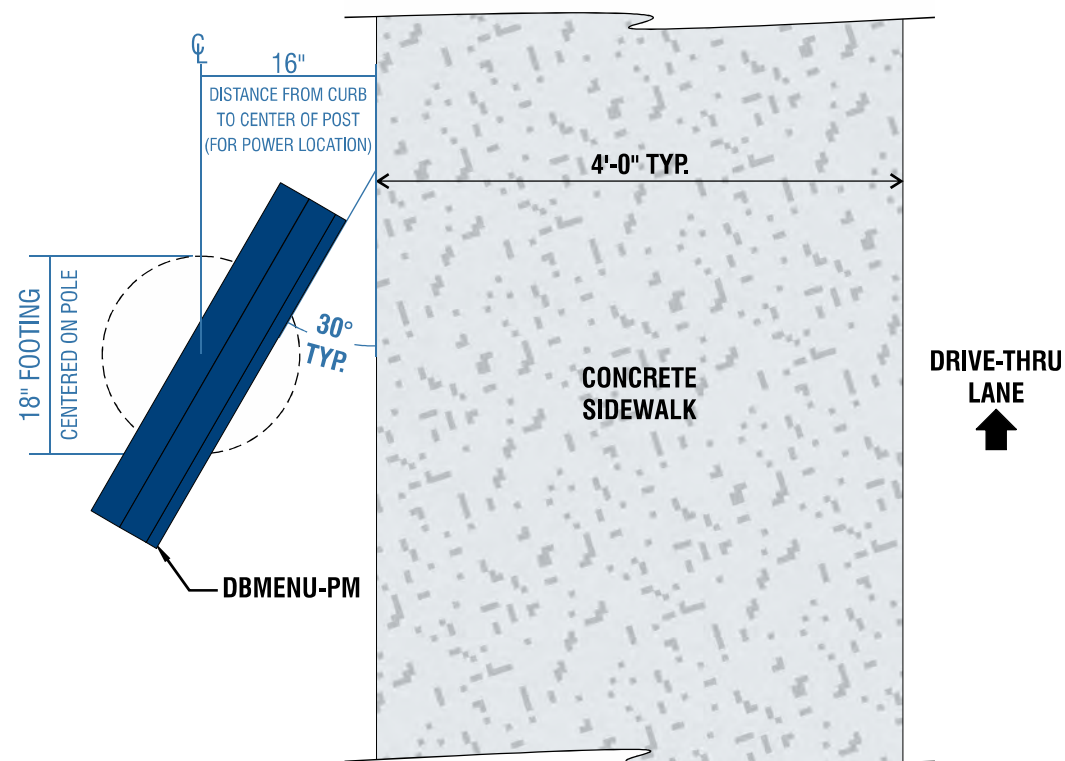

**Preferred install method: expansion bolts into existing concrete pad.
Alternate install method: Concrete footing installed by GC with electrical conduit in the center of the pier where appropriate.**

QTY. 4

Scale: 1" = 1'-0"


**N6 SIGN TYPE : S/F FREE STANDING MENU BOARD
TOTAL SQ. FT.: 10.70**



LOREN INDUSTRIES

12226 Coast Drive
Whittier, CA 90601
Tel: (562) 946-7545
Fax: (562) 949-5707
St. Lic.: 455415

Los Angeles, CA

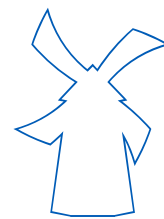

DRAWING/REVISION NO.:

08-21-0001R3

PAGE NO.:

10 OF 15

CLIENT:

DUTCH BROS

ADDRESS

Hillcrest Ave
Antioch, Ca.

Approval Signature

DATE:

08/04/2021

PROJECT MANAGER

Carla T.

DESIGNER:

Jose Soria

REVISION DATE:

08/27/2021

REVISION BY:

Adrian C.

ALL IDEAS, PLANS, AND ELECTRONIC ART INDICATED ON THIS DRAWING ARE COPYRIGHTED AND OWNED BY LOREN ELECTRIC SIGN CORPORATION AND SHALL NOT BE REPRODUCED, USED BY OR DISCLOSED TO ANY PERSONS, FIRM OR CORPORATION FOR ANY PURPOSE WHATSOEVER WITHOUT PERMISSION OF LOREN ELECTRIC SIGN CORPORATION.



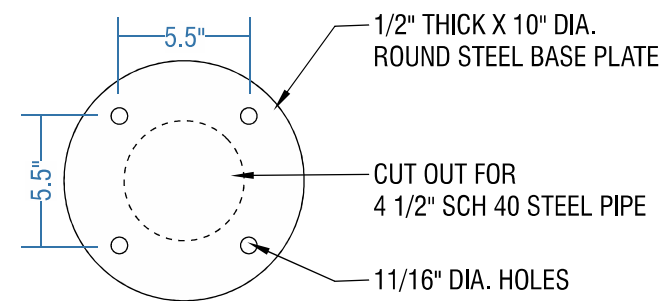


PLATE DETAIL
SCALE: 1 1/2" = 1'-0"

N7 SIGN TYPE CLB: S/F POST MOUNTED DOUBLE ARM CLEARANCE BAR W/PIVOTING ARMS
TOTAL SQ. FT.: 33.19 Scale: 1/2" = 1'-0"


- STEEL POLE SUPPORT STRUCTURE WITH FABRICATED .090 ALUMINUM BOLT COVER. PAINT DB CUSTOM DARK BLUE.
- REFLECTIVE WHITE PSV COPY APPLIED TO VERTICAL POLE.
- 3" DIA. WHITE PVC CLEARANCE BAR WITH END CAPS AND 280-75 REFLECTIVE BLUE PSV TEXT & STRIPES.
- HANG WITH BLACK CHAIN SECURED TO BOTTOM OF POLE STRUCTURE.
- INCLUDE ONE SHEET REFLECTIVE VINYL NUMBERS MASKED FOR FIELD INSTALLATION.
- CLEARANCE NUMBERS TO BE FIELD MEASURED AND APPLIED. MEASURE FROM ASPHALT TO BOTTOM OF OVERHANG MINUS 6".
- ACM 'DRIVE-THRU' SIGN WITH DIAMOND GRADE REFLECTIVE VINYL WITH DIGITALLY PRINTED BLUE.
- DIAMOND GRADE REFLECTIVE WHITE VINYL WITH DIGITALLY PRINTED PMS 541 C BLUE BACKGROUND.
- INSTALL STEEL POLE PLATE-MOUNTED WITH LEVELING NUTS ONTO G.C. PROVIDED FOOTING.

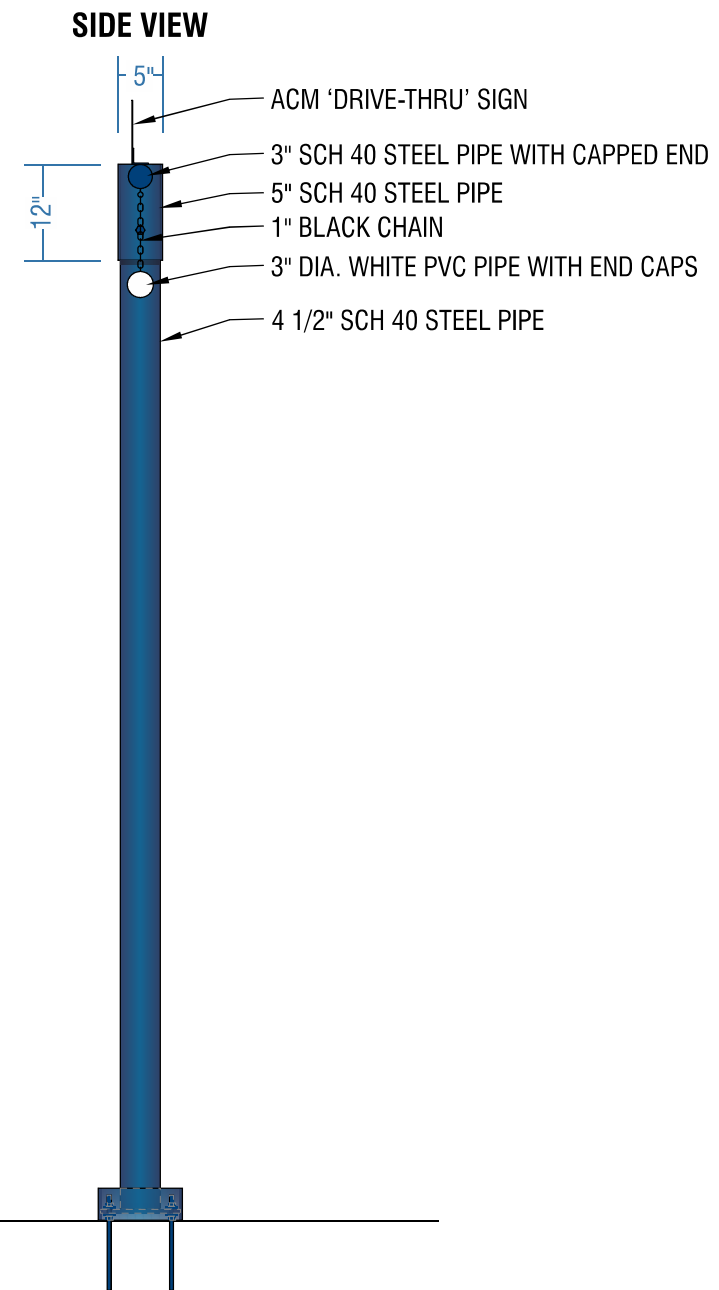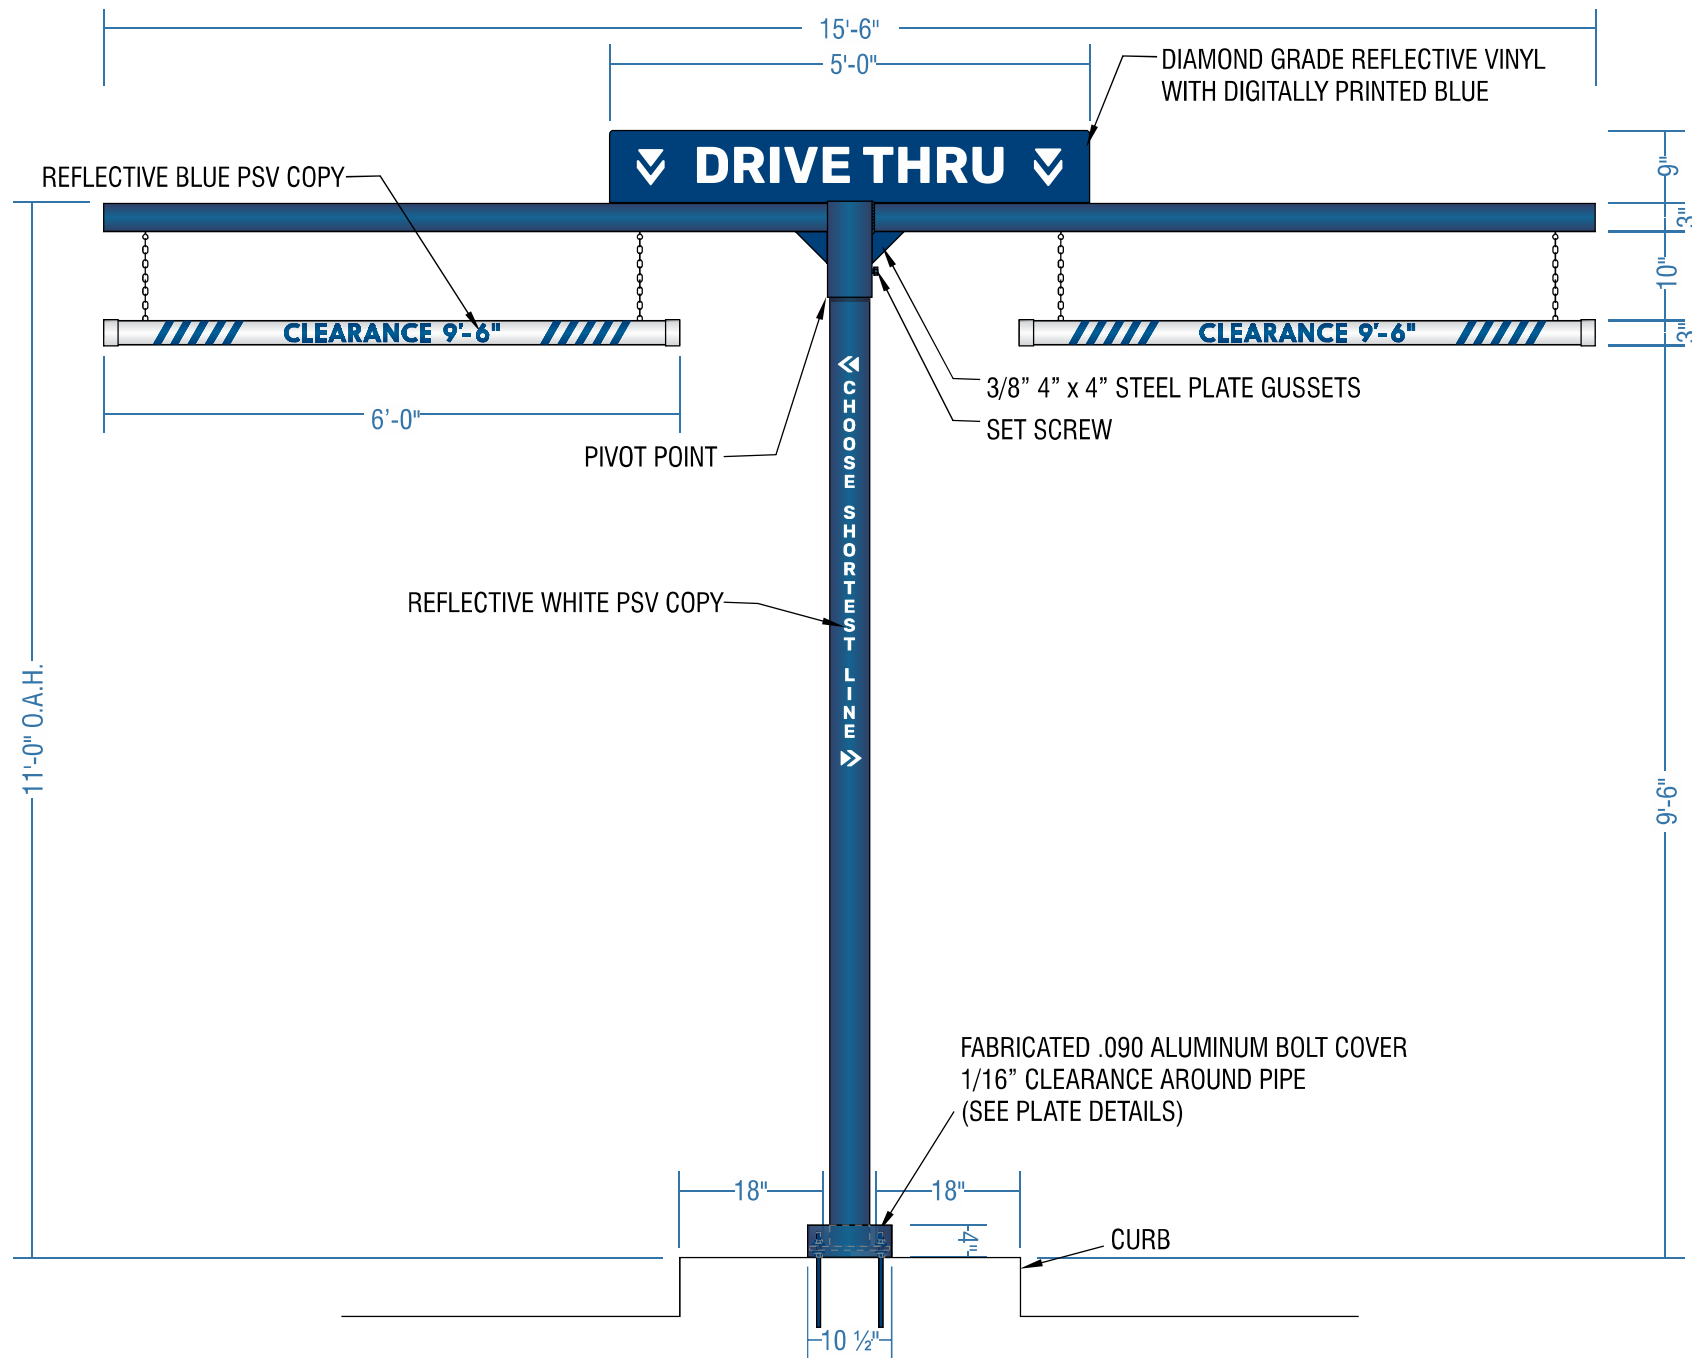

LOREN INDUSTRIES

12226 Coast Drive
Whittier, CA 90601
Tel: (562) 946-7545
Fax: (562) 949-5707
St. Lic.: 455415

Los Angeles, CA

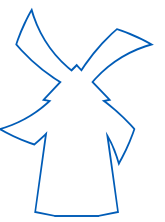

DRAWING/REVISION NO.:

08-21-0001R3

PAGE NO.:

11 OF 15

CLIENT:

DUTCH BROS

ADDRESS

Hillcrest Ave
Antioch, Ca.

Approval Signature

DATE:

08/04/2021

PROJECT MANAGER

Carla T.

DESIGNER:

Jose Soria

REVISION DATE:

08/27/2021

REVISION BY:

Adrian C.

ALL IDEAS, PLANS, AND ELECTRONIC ART INDICATED ON THIS DRAWING ARE COPYRIGHTED AND OWNED BY LOREN ELECTRIC SIGN CORPORATION AND SHALL NOT BE REPRODUCED, USED BY OR DISCLOSED TO ANY PERSONS, FIRM OR CORPORATION FOR ANY PURPOSE WHATSOEVER WITHOUT PERMISSION OF LOREN ELECTRIC SIGN CORPORATION.




LOREN

LOREN INDUSTRIES

12226 Coast Drive
Whittier, CA 90601
Tel: (562) 946-7545
Fax: (562) 949-5707
St. Lic.: 455415

Los Angeles, CA

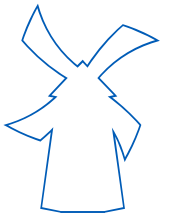

DRAWING/REVISION NO.:

08-21-0001R3

PAGE NO.:

12 OF 15

CLIENT:

DUTCH BROS

ADDRESS

Hillcrest Ave
Antioch, Ca.

Approval Signature

DATE:

08/04/2021

PROJECT MANAGER

Carla T.

DESIGNER:

Jose Soria


REVISION DATE:

08/27/2021


REVISION BY:

Adrian C.


ALL IDEAS, PLANS, AND ELECTRONIC ART INDICATED ON THIS DRAWING ARE COPYRIGHTED AND OWNED BY LOREN ELECTRIC SIGN CORPORATION AND SHALL NOT BE REPRODUCED, USED BY OR DISCLOSED TO ANY PERSONS, FIRM OR CORPORATION FOR ANY PURPOSE WHATSOEVER WITHOUT PERMISSION OF LOREN ELECTRIC SIGN CORPORATION.

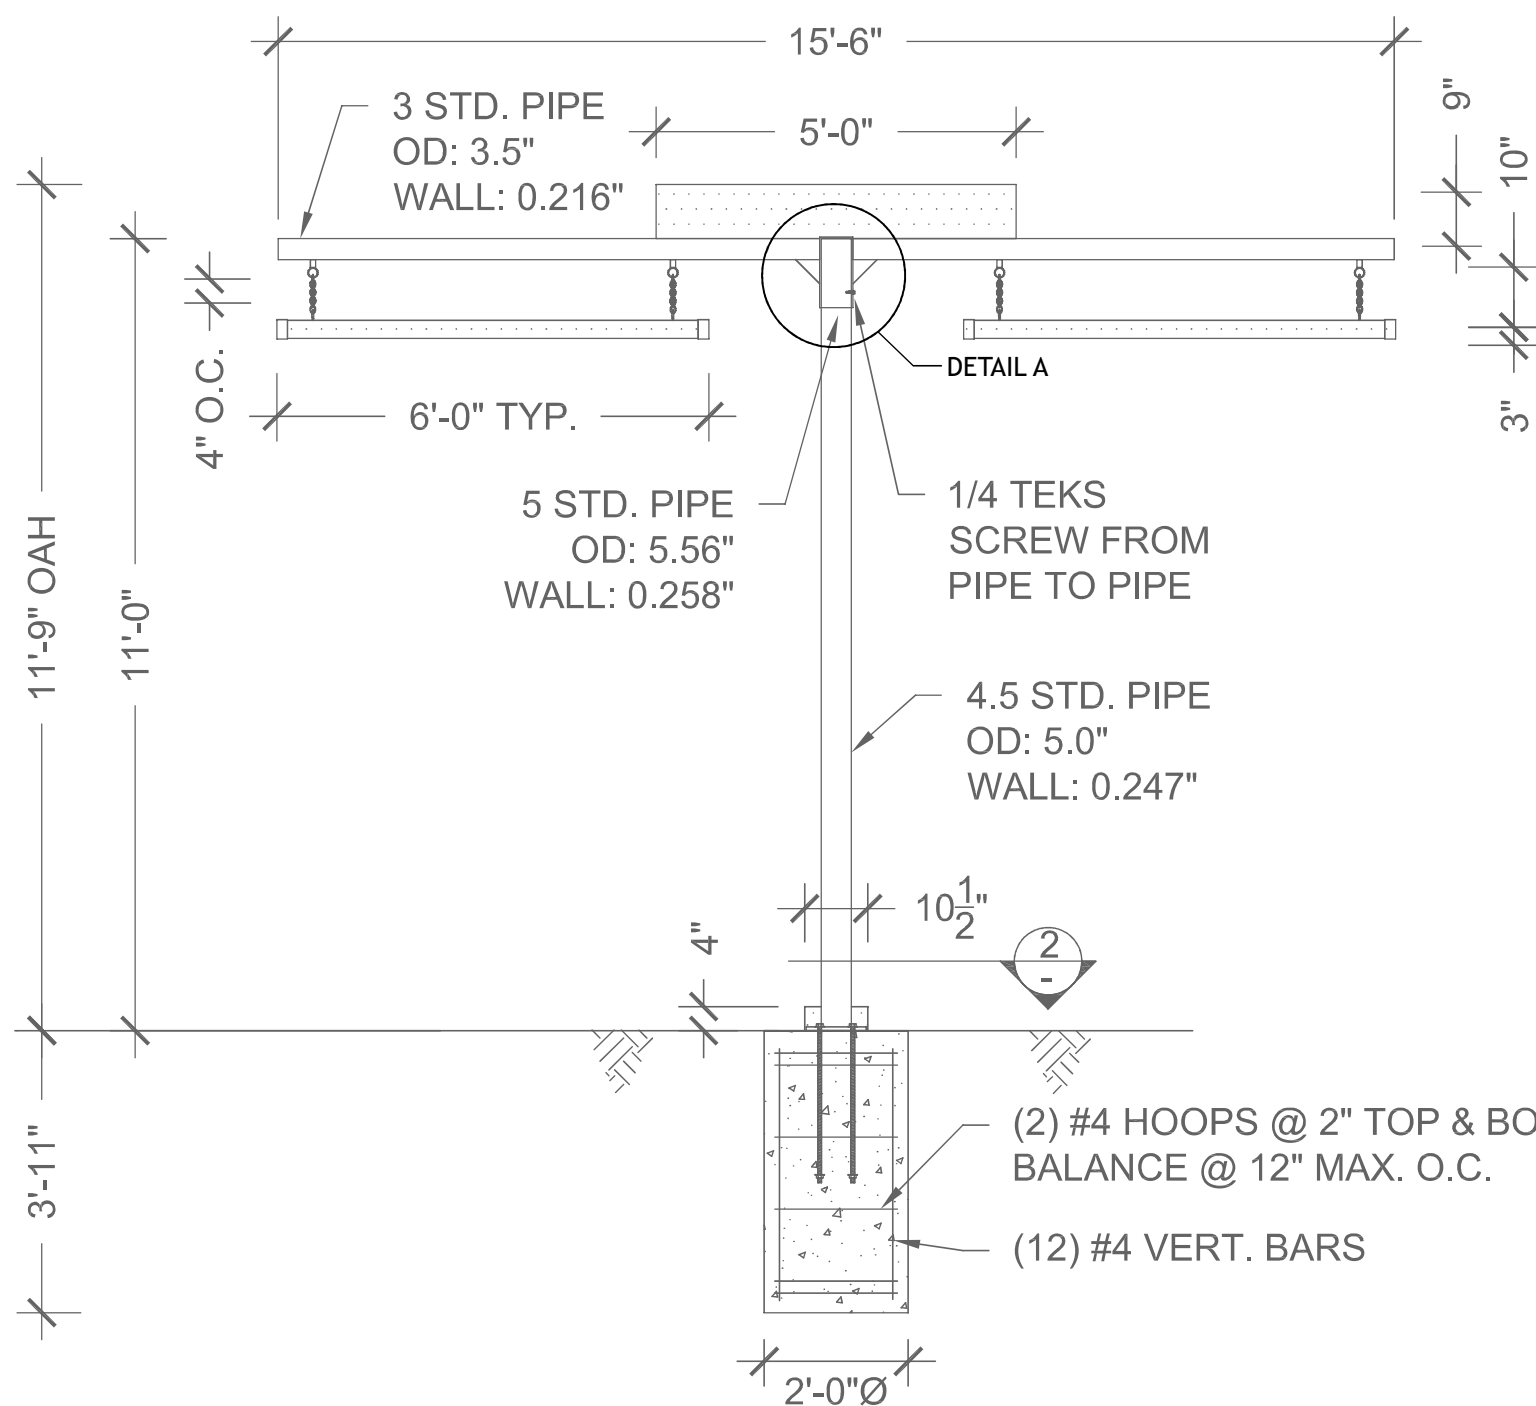

**ELEVATION
SCALE: 3/8" = 1'-0"**

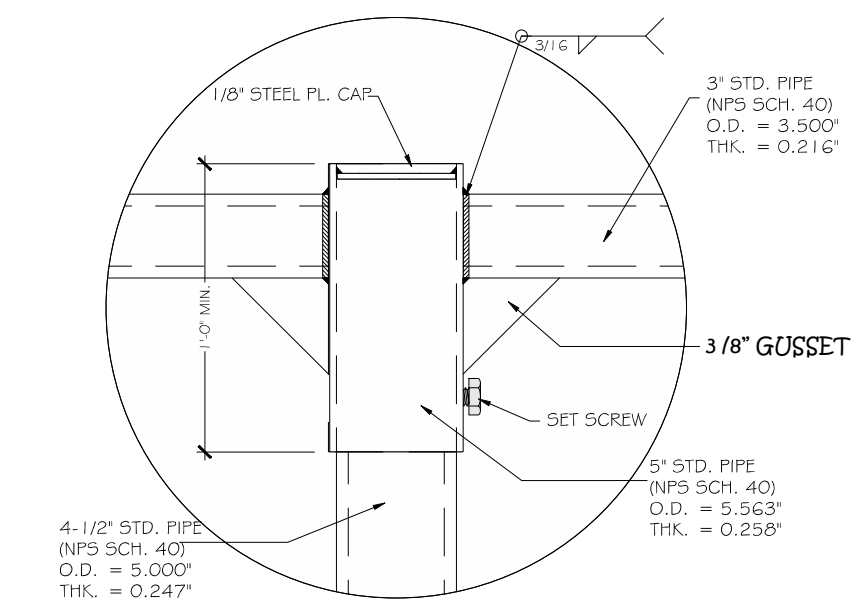

**DETAIL A
Scale: 1" = 1'-0"**

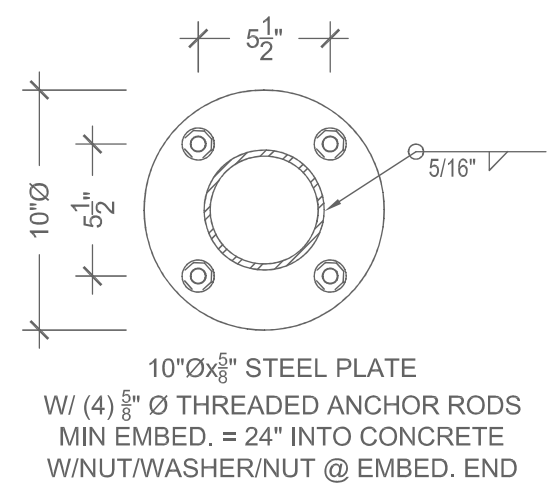

**BASE PLATE
SCALE: 1 1/2" = 1'-0"**



LOREN

LOREN INDUSTRIES


12226 Coast Drive
Whittier, CA 90601

Tel: (562) 946-7545

Fax: (562) 949-5707

St. Lic.: 455415

Los Angeles, CA

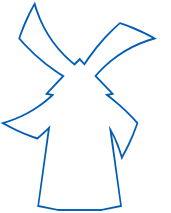

DRAWING/REVISION NO.:

08-21-0001R3

PAGE NO.:

13 OF **15**

CLIENT:

DUTCH BROS

ADDRESS

Hillcrest Ave
Antioch, Ca.

Approval Signature

DATE:

08/04/2021

PROJECT MANAGER

Carla T.

DESIGNER:

Jose Soria



REVISION DATE:

08/27/2021

REVISION BY:

Adrian C.

ALL IDEAS, PLANS, AND ELECTRONIC ART INDICATED ON THIS DRAWING ARE COPYRIGHTED AND OWNED BY LOREN ELECTRIC SIGN CORPORATION AND SHALL NOT BE REPRODUCED, USED BY OR DISCLOSED TO ANY PERSONS, FIRM OR CORPORATION FOR ANY PURPOSE WHATSOEVER WITHOUT PERMISSION OF LOREN ELECTRIC SIGN CORPORATION.

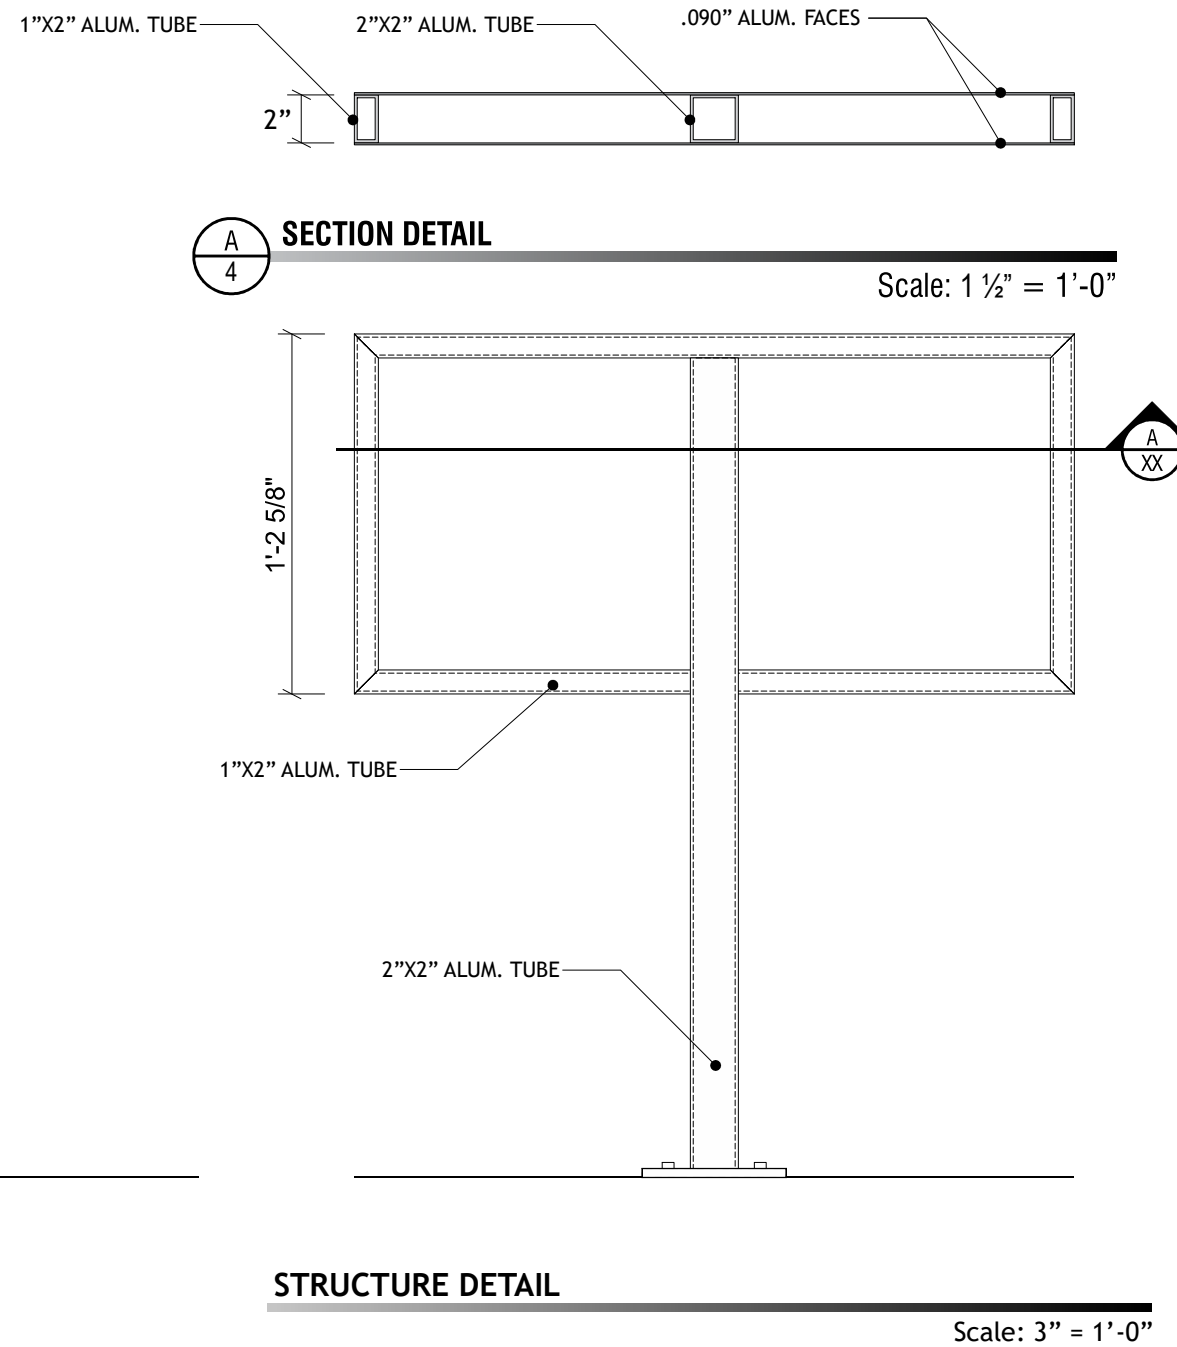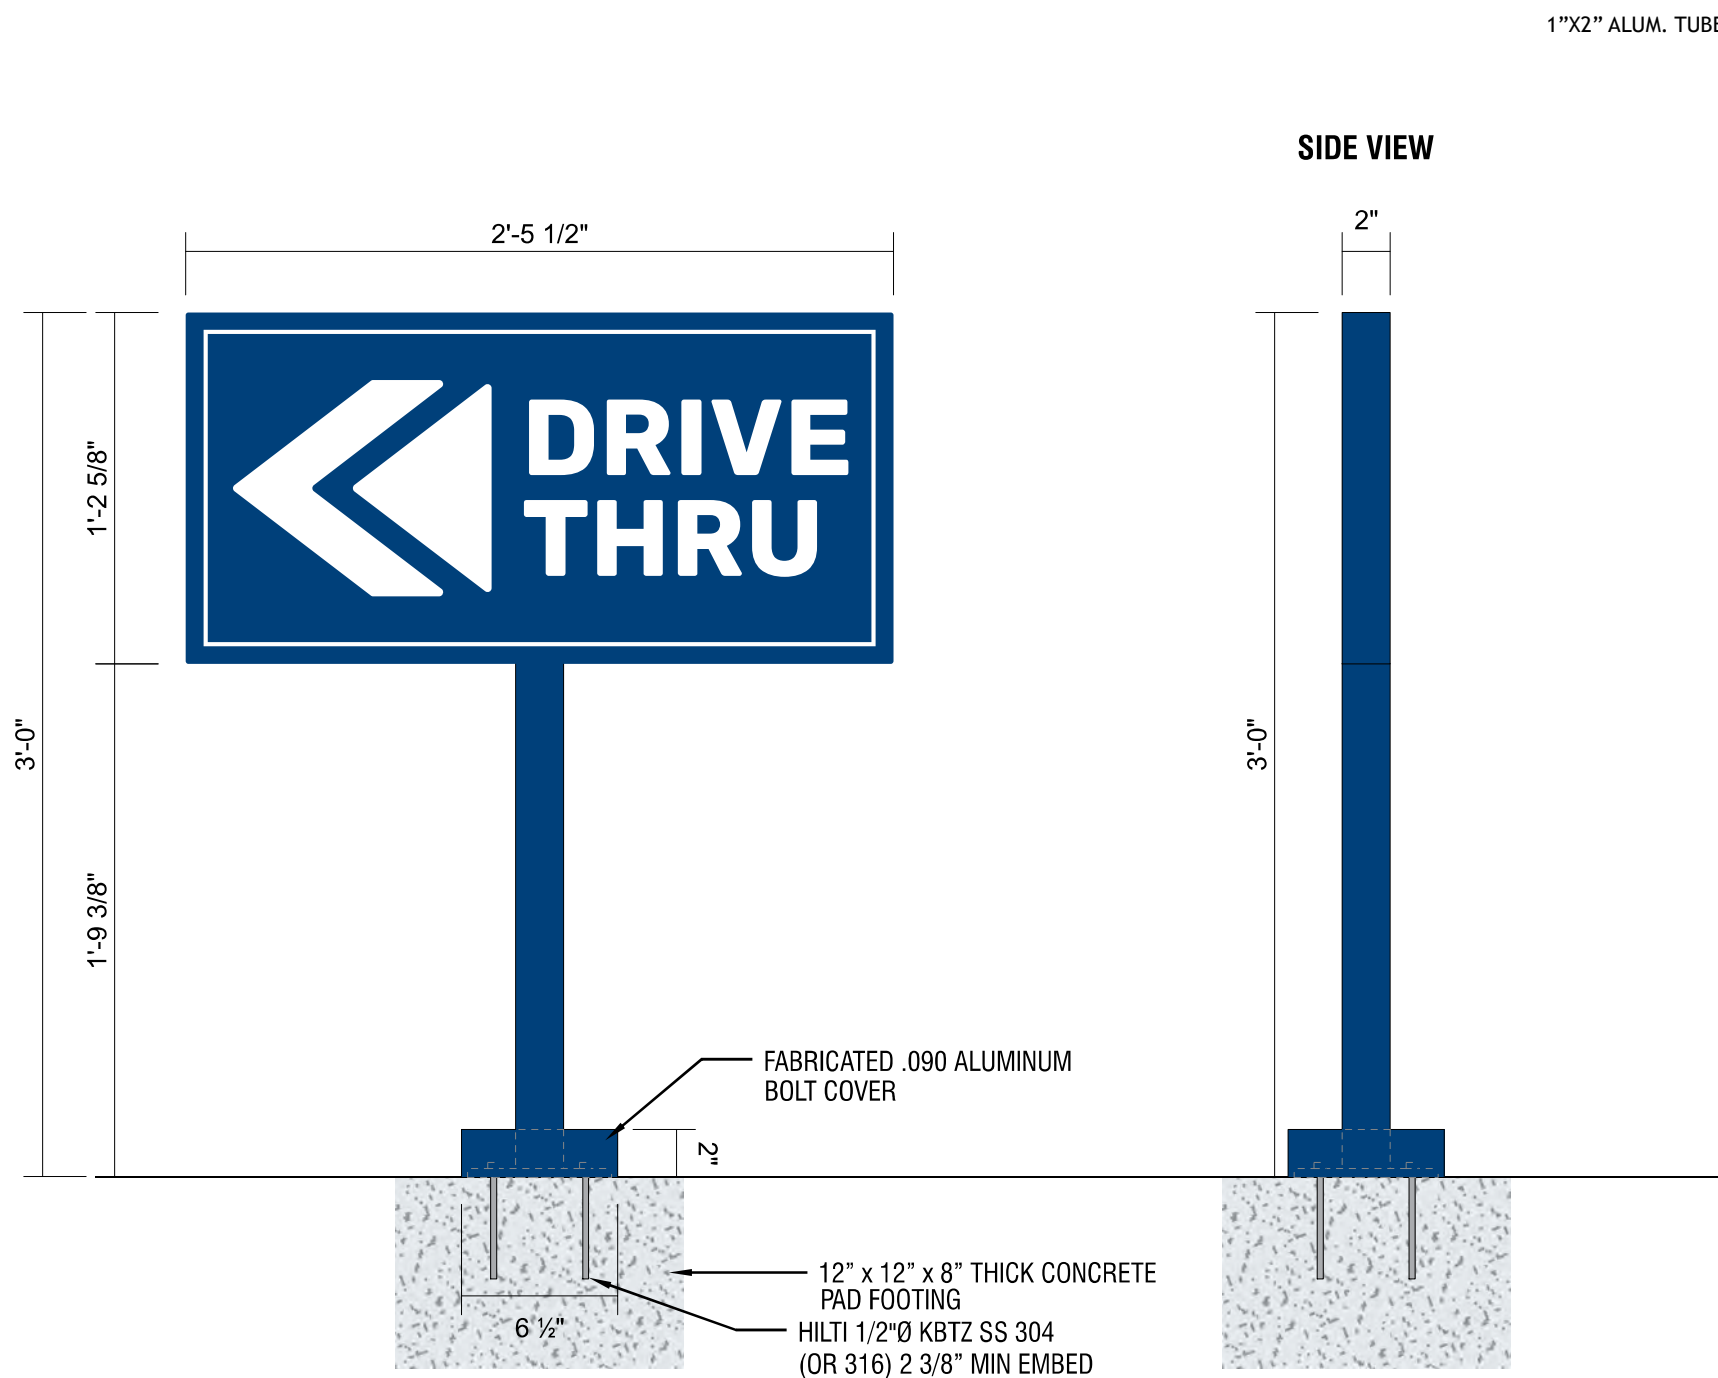

N8

SIGN TYPE DB/DIR: NON-ILLUMINATED D/F DIRECTIONAL (QTY. 2)


TOTAL SQ. FT.: 3.13

Scale: 3" = 1'-0"

DIAMOND GRADE REFLECTIVE WHITE VINYL WITH DIGITALLY PRINTED PMS 541 C BLUE BACKGROUND
2" X 2" SQUARE TUBE ALUMINUM FRAME & POST WITH ALUMINUM FACES & 3/8" X 6" X 6" PLATE
FABRICATED .090 ALUMINUM BOLT COVER
PAINT PMS 541 C
INSTALL PLATE-MOUNT SIGN WITH HILTI KWIK BOLTS
PAD FOOTING INSTALLED BY GC

Footing and concrete provided and installed by sign installer.

COLOR CODE

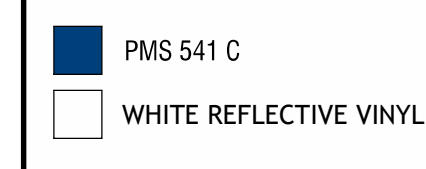




LOREN

LOREN INDUSTRIES

12226 Coast Drive
Whittier, CA 90601
Tel: (562) 946-7545
Fax: (562) 949-5707
St. Lic.: 455415

Los Angeles, CA

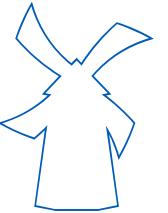

DRAWING/REVISION NO.:

08-21-0001R3

PAGE NO.:

14 OF **15**

CLIENT:

DUTCH BROS

ADDRESS

Hillcrest Ave
Antioch, Ca.

Approval Signature

DATE:

08/04/2021

PROJECT MANAGER

Carla T.

DESIGNER:

Jose Soria


REVISION DATE:

08/27/2021

REVISION BY:


Adrian C.

ALL IDEAS, PLANS, AND ELECTRONIC ART INDICATED ON THIS DRAWING ARE COPYRIGHTED AND OWNED BY LOREN ELECTRIC SIGN CORPORATION AND SHALL NOT BE REPRODUCED, USED BY OR DISCLOSED TO ANY PERSONS, FIRM OR CORPORATION FOR ANY PURPOSE WHATSOEVER WITHOUT PERMISSION OF LOREN ELECTRIC SIGN CORPORATION.

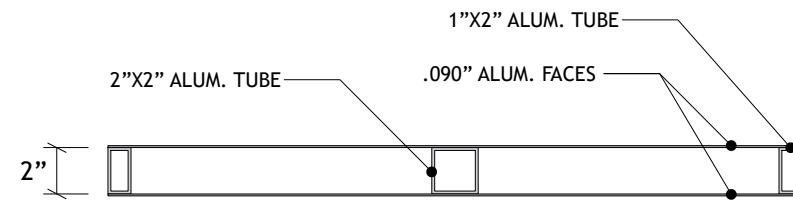


SECTION DETAIL

Scale: 1 1/2" = 1'-0"

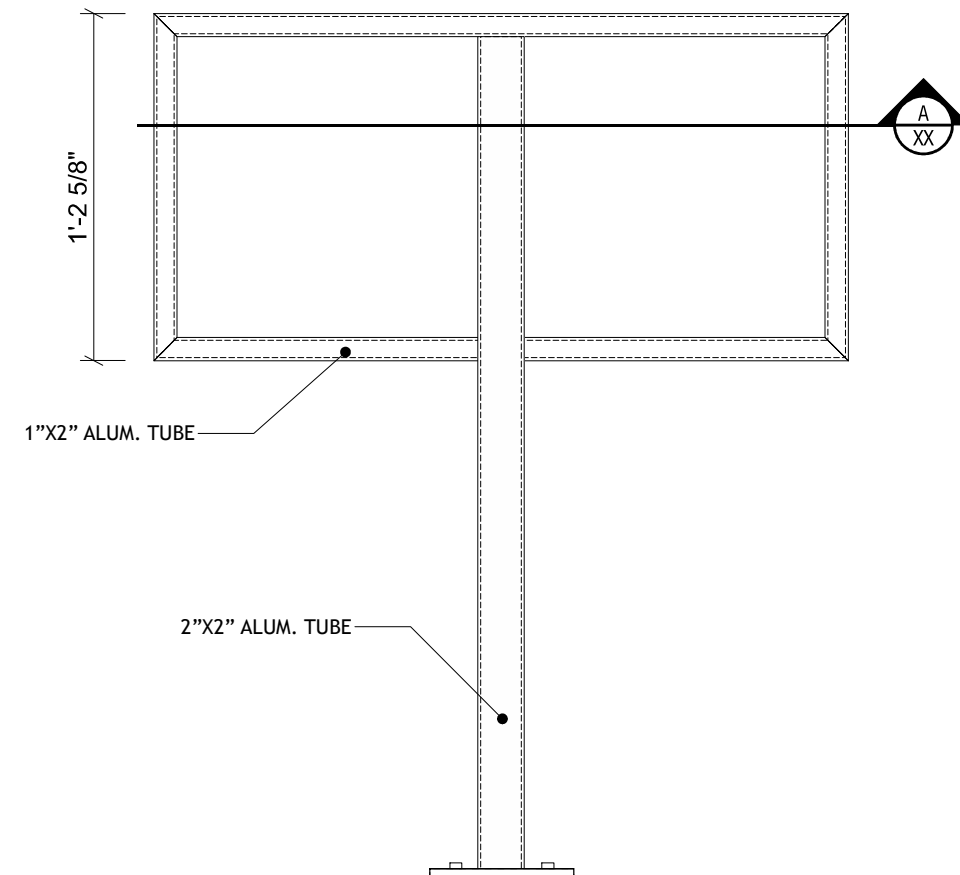

STRUCTURE DETAIL

Scale: 3" = 1'-0"

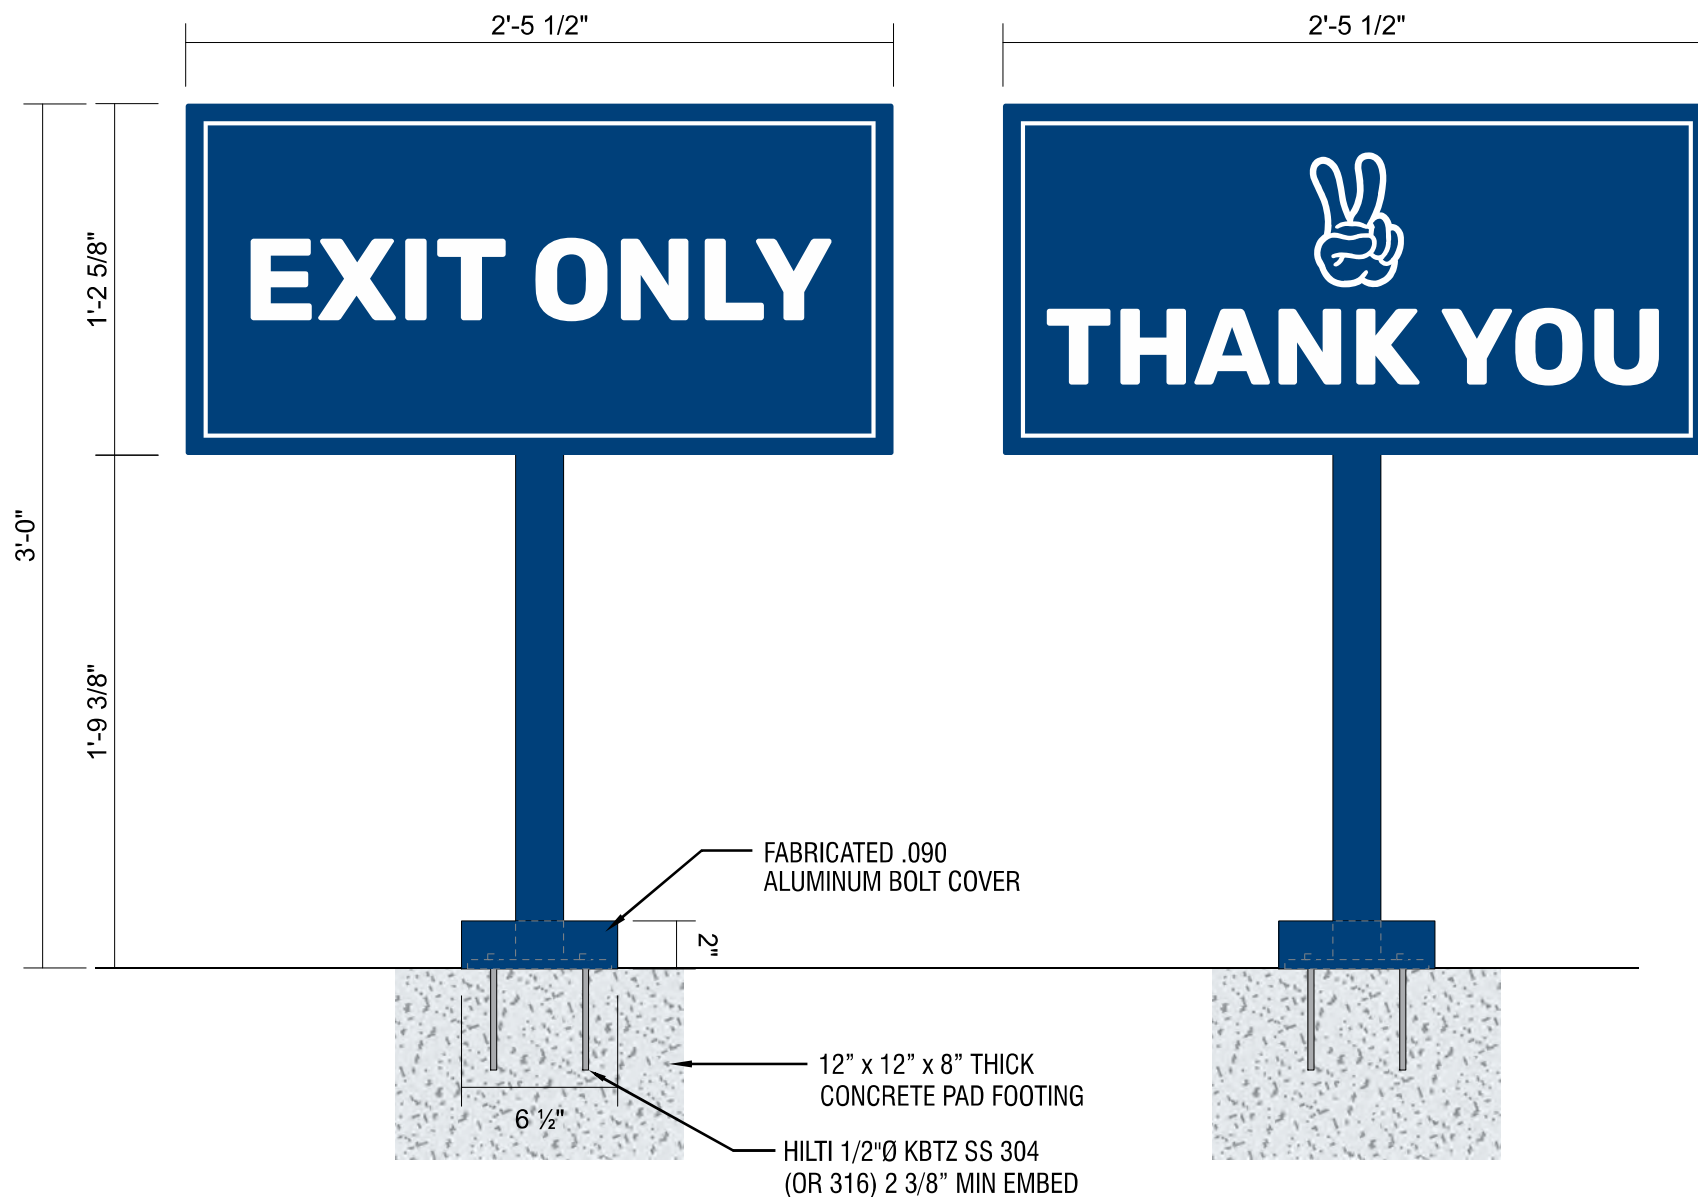

N9

SIGN TYPE DB/DIR: NON-ILLUMINATED D/F DIRECTIONAL (QTY. 1)


TOTAL SQ. FT.: 1.82

Scale: 3" = 1'-0"

**DIAMOND GRADE REFLECTIVE WHITE VINYL WITH DIGITALLY PRINTED PMS 541 C BLUE BACKGROUND
2" X 2" SQUARE TUBE ALUMINUM FRAME & POST WITH ALUMINUM FACES & 3/8" X 6" X 6" PLATE
FABRICATED .090 ALUMINUM BOLT COVER
PAINT PMS 541 C
INSTALL PLATE-MOUNT SIGN WITH HILTI KWIK BOLTS
PAD FOOTING INSTALLED BY GC**

Footing and concrete provided and installed by sign installer.

COLOR CODE

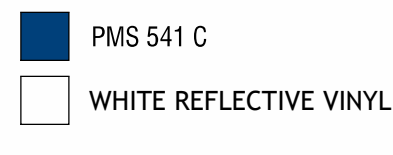




LOREN

LOREN INDUSTRIES

12226 Coast Drive
Whittier, CA 90601
Tel: (562) 946-7545
Fax: (562) 949-5707
St. Lic.: 455415

Los Angeles, CA

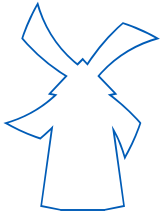

DRAWING/REVISION NO.:

08-21-0001R3

PAGE NO.:

15 OF 15

CLIENT:

DUTCH BROS

ADDRESS

Hillcrest Ave
Antioch, Ca.

Approval Signature

DATE:

08/04/2021

PROJECT MANAGER

Carla T.

DESIGNER:

Jose Soria


REVISION DATE:

08/27/2021


REVISION BY:

Adrian C.

ALL IDEAS, PLANS, AND ELECTRONIC ART INDICATED ON THIS DRAWING ARE COPYRIGHTED AND OWNED BY LOREN ELECTRIC SIGN CORPORATION AND SHALL NOT BE REPRODUCED, USED BY OR DISCLOSED TO ANY PERSONS, FIRM OR CORPORATION FOR ANY PURPOSE WHATSOEVER WITHOUT PERMISSION OF LOREN ELECTRIC SIGN CORPORATION.

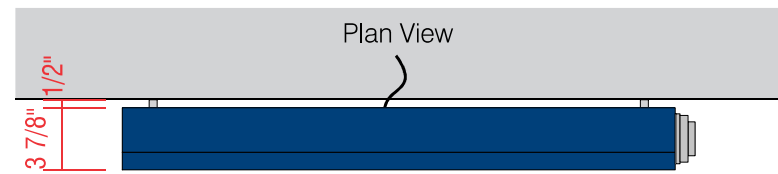

ATTACHMENT DETAIL
ILLUMINATED WALL MOUNTED MENU

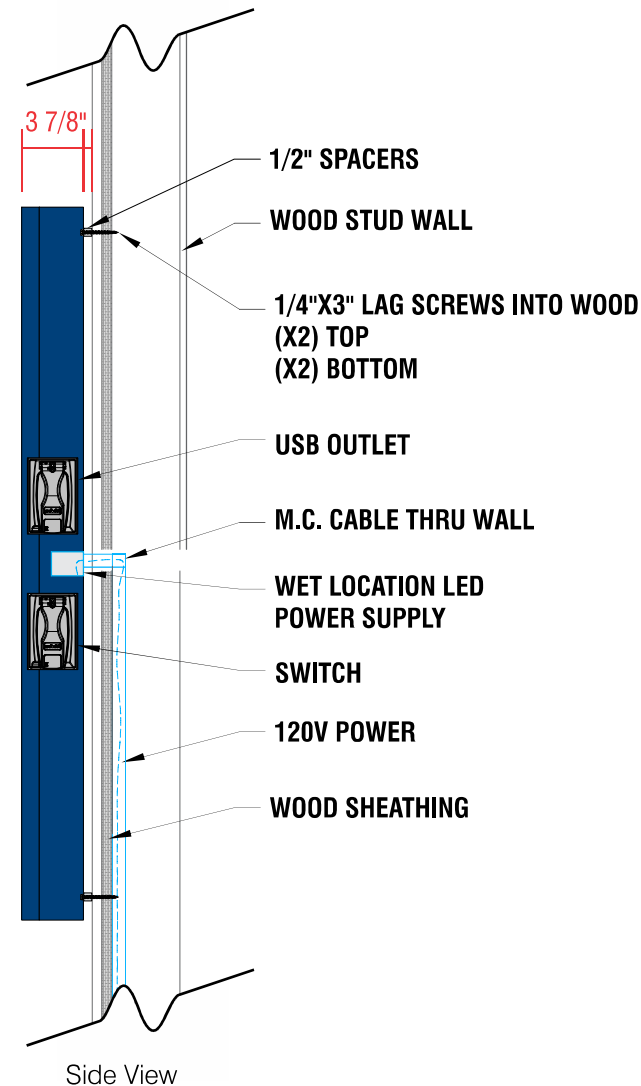

A WALL-MOUNTED, BACKLIT MENU SIGN

- PRINTED MENU PANEL NOT INCLUDED
- LED OUTDOOR LIGHT BOX
- LOCKABLE HINGED DOOR
- ALUMINUM CONSTRUCTION

B PRINTED LIGHT GUIDE PANEL

- AS SEPARATE ORDER

COLOR CODE



DIGITAL PRINT



DB CUSTOM DARK BLUE

COLOR CODE



DIGITAL PRINT



POWDER COATED
DB CUSTOM DARK BLUE



POWDER COATED SILVER

N10

SIGN TYPE : V5 S/F WALL MOUNTED MENU BOARD

TOTAL SQ. FT.: 10.70

QTY. 4

Scale: 1" = 1'-0"